

THIS DRAWING IS TO BE READ IN CONJUNCTION WITH ALL RELEVANT SPECIFICATIONS AND DRAWINGS ISSUED. FOR DISCREPANCIES OR OMISSIONS CONTACT MOBILE CAD SURVEYING SOLUTIONS LTD PRIOR TO WORK COMMENCING. THE CONTRACTOR IS TO CHECK AND VERIFY ALL BUILDING AND SITE DIMENSIONS AND LEVELS BEFORE WORK COMMENCES.

© COPYRIGHT MOBILE CAD SURVEYING SOLUTIONS LTD 2019

DO NOT SCALE THIS DRAWING - CHECK ALL DIMENSIONS ON SITE

NOTE:
AREAS DRAWN INDICATIVELY NOTED AND INDICATED BY GREY DASHED LINE AS LINE BELOW


LEVEL DATUM & ORIENTATION

GEOGRAPHICAL ORIENTATION & NORTH POINT SHOWN ARE INDICATIVE ONLY.
ARBITRARY LEVELS CO-ORDINATED TO LOCAL STATIONS POSITIONED ON SITE DURING SURVEY.

ABBREVIATIONS & LEGEND:


LEVELS & HEIGHTS	SERVICES
CL - COVER LEVEL	BT - BRITISH TELECOMS
IL - INVERT LEVEL	CATV - CABLE TELEVISION
L - LEVEL	ER - EARTHING ROE
HT - HEIGHT	ES - ELECTRICAL SUPPLY
STN - SURVEY STATION	FS - FIRE HYDRANT
BH - BEAM	GAS - GAS SUPPLY
CE - CEILING	PO - POST OFFICE TELEPHONE
J - JOISTS	SV - STOP VALVE
RA - RAFTERS	TSSU - TRAFFIC LIGHT SIGNALS
E - EAVES	
FR - FLAT ROOF	
P - PARAPET	
F - FENCE	
US - UNDERSIDE OF	
R - ROOF	
SL - SLAB	
SF - SOFFIT	
T - TREE	
THR - THRESHOLD	
To - TOP OF	
W - WALL	
HH - HEAD HEIGHT	
OH - OPENING HEIGHT	
SH - SILL HEIGHT	

GENERAL NOTES	TYPICAL DRAWING SYMBOLS
AB - ADVERTISING BOARD	SPOT LEVEL X 96.256
AC - AIR CONDITIONING UNIT	SPOT HEIGHT X 99.034
ARU - AIR HANDLING UNIT	
AP - AIR PURIFIER ALARM PANEL	
B - BOLLARD	
BA - BARRIER	
BE - BENCH	
BS - BUS STOP	
BU - BUILE	
BXD - BOXING OUT	
CAN - CEILING ACCESS HATCH	
CH - CHIPNEY	
CFD - CLIPBOARD	
DB - DOG WASTE BIN	
DW - DWARF WALL	
DK - DROP KEYS	
EDB - ELECTRICAL DISTRIBUTION BOARD	
EG - EXTRACT GRILLE	
EM - ELECTRIC METER	
FB - FUSE BOX	
FR - FIREPLACE	
FU - FUSE	
FAP - FIRE ALARM PANEL	
GU - GUARDING	
GM - GAS METER	
HWC - HOT WATER CYLINDER	
LAM - LOFT ACCESS HATCH	
LB - LITTER BIN	
LP - LAMP POST	
PC - PAVING CROSSING	
PS - PAVING SLABS	
PL - PAVEMENT LIGHT	
PLT - PLANTING	
PB - POST BOX	
RS - RAILING	
RS - ROAD SIGN	
SP - SPEED BUMP	
SG - SIGNAGE	
SN - STREET NAME SIGN	
SWR - SHELVE	
TR - TELEPHONE BOX	
TL - TRAFFIC LIGHT	
TM - TICKET MACHINE	
TP - TELEGRAPH POLE	
VE - VEGETATION	
W - WATER	
WD - WARDROBE	
WH - WATER HEATER	
ZC - ZEBRA CROSSING	

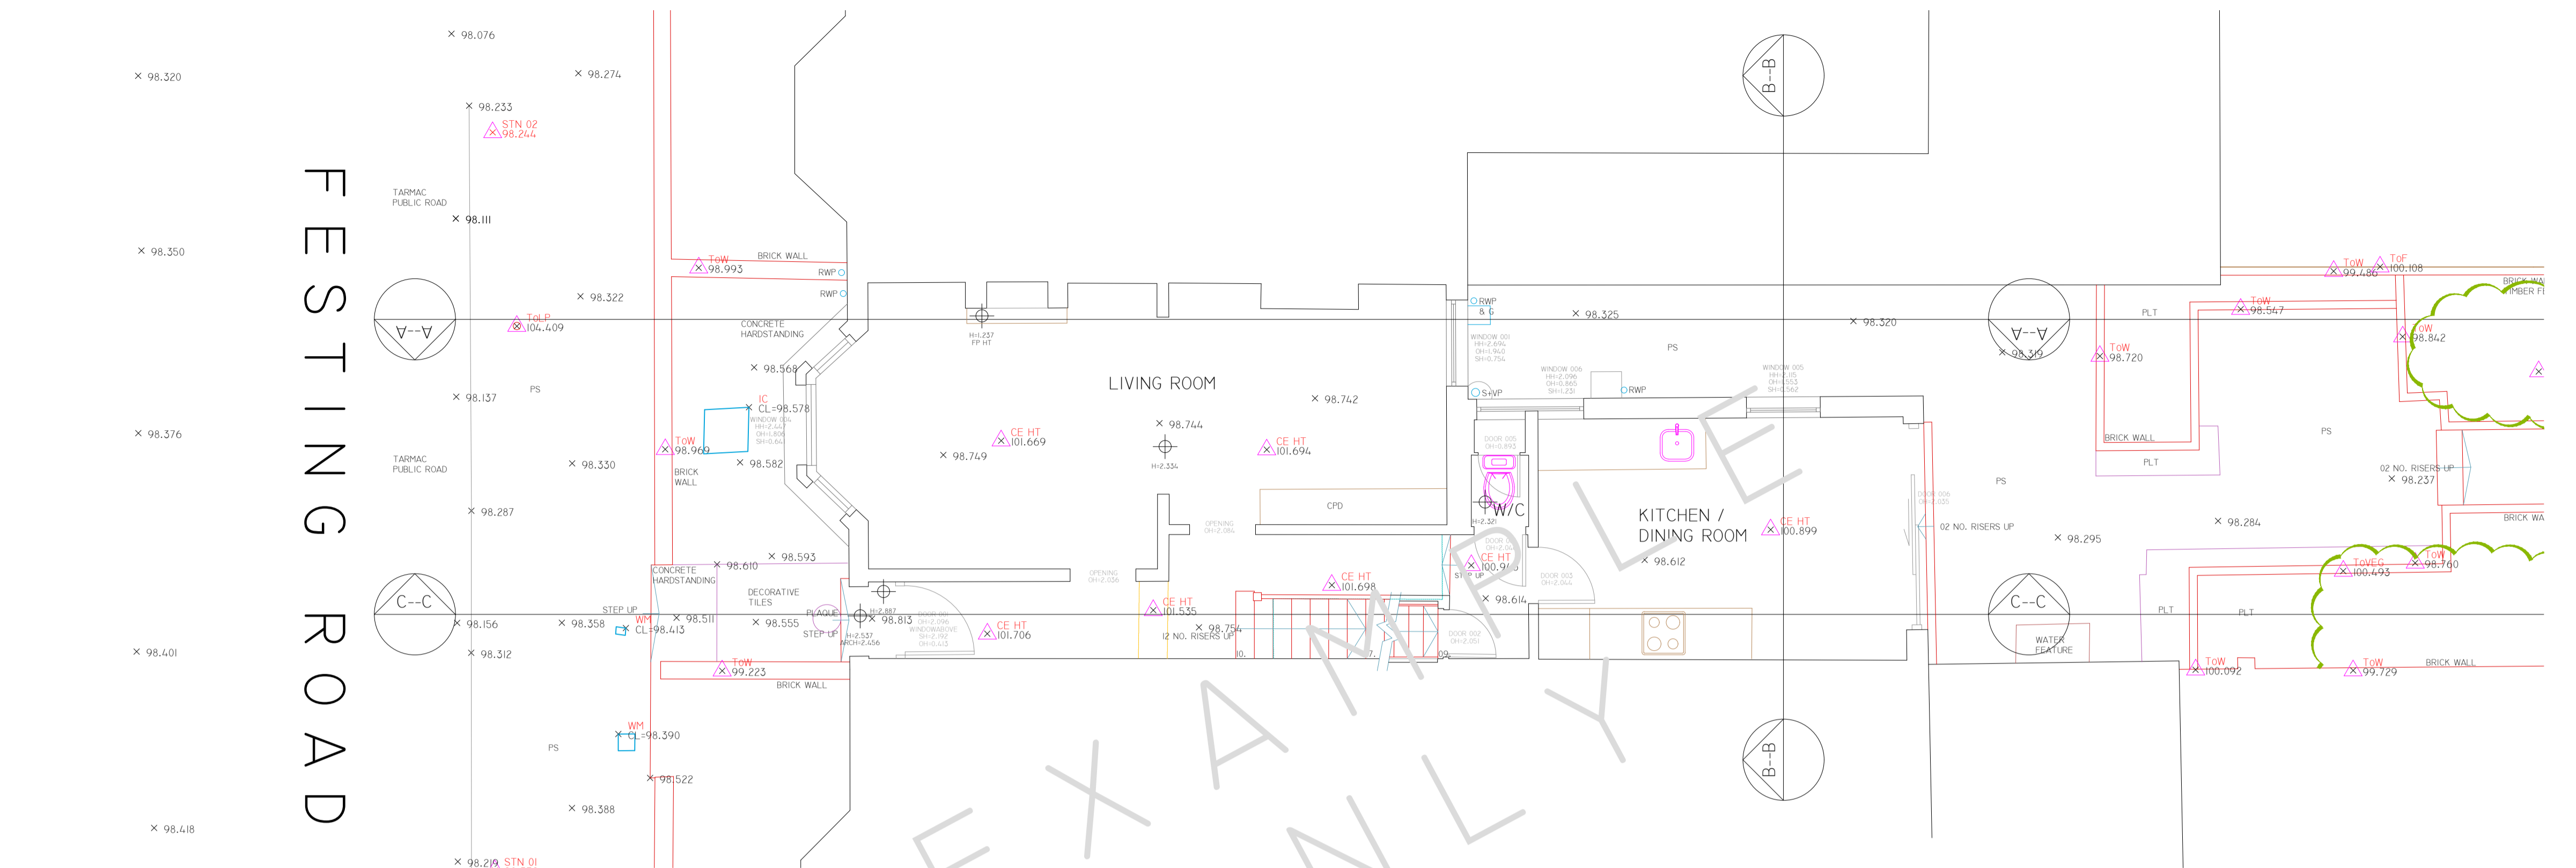

GROUND FLOOR
1:50 SCALE

LOWER GROUND FLOOR
1:50 SCALE

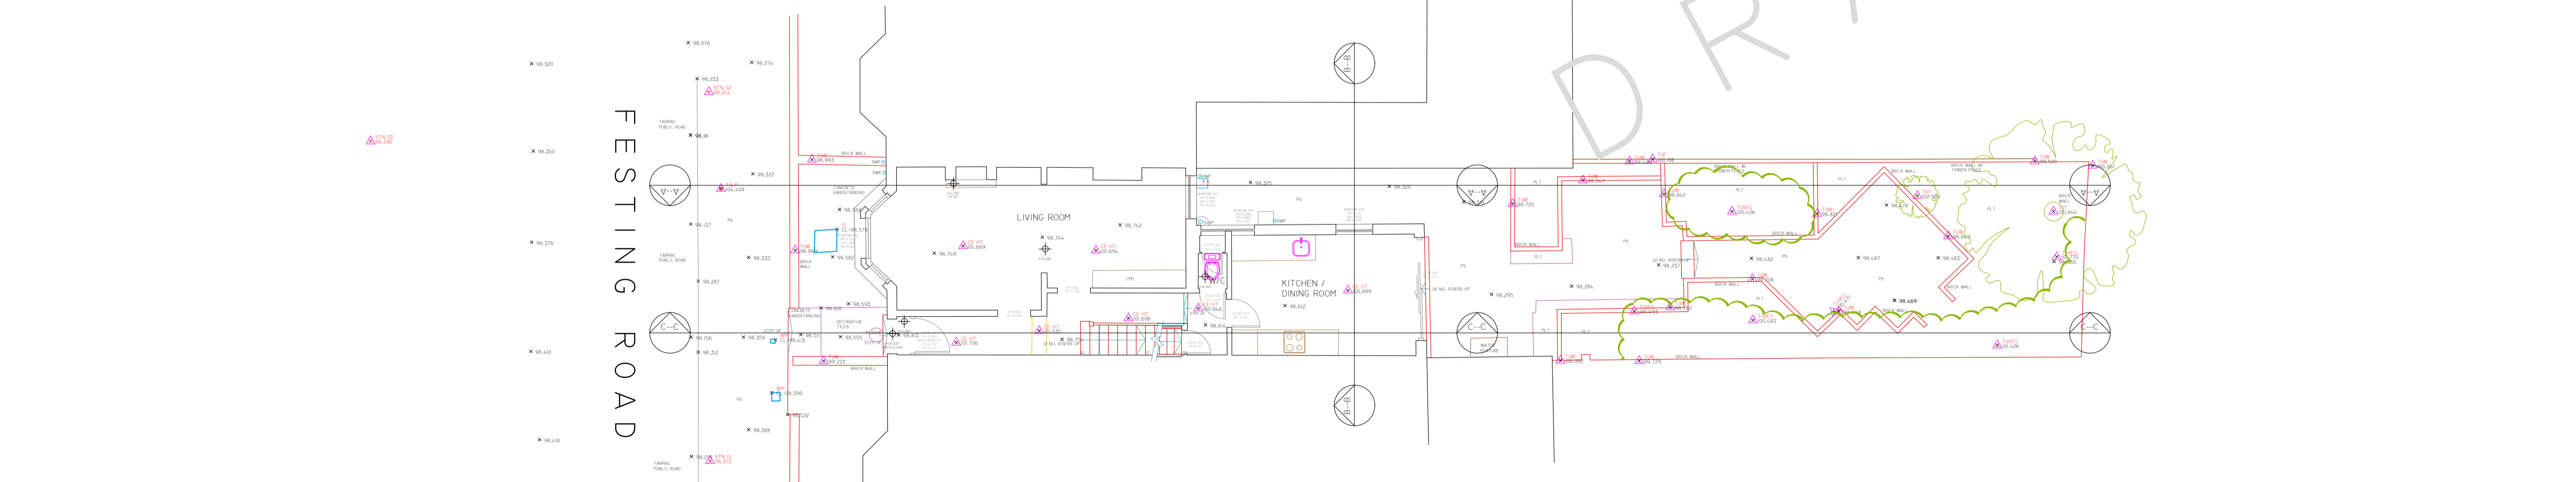

SITE PLAN
1:100 SCALE

REV	DATE	AMENDMENTS

Mobile CAD Surveying office & on site

PROJECT: MEASURED BUILDING SURVEY
ADDRESS: 33 FESTING ROAD

DWG NO.: 01
DWG TITLE: LGF & GROUND FLOOR
DWG DATE: 2019
DWG SIZE: SCALE AS SHOWN @ A1
DRAWN: JH | CHECKED: JW | ISSUE:


THIS DRAWING IS TO BE READ IN CONJUNCTION WITH ALL RELEVANT SPECIFICATIONS AND DRAWINGS ISSUED. FOR DISCREPANCIES OR OMISSIONS CONTACT MOBILE CAD SURVEYING SOLUTIONS LTD PRIOR TO WORK COMMENCING. THE CONTRACTOR IS TO CHECK AND VERIFY ALL BUILDING AND SITE DIMENSIONS AND LEVELS BEFORE WORK COMMENCES.

© COPYRIGHT MOBILE CAD SURVEYING SOLUTIONS LTD 2019

DO NOT SCALE THIS DRAWING - CHECK ALL DIMENSIONS ON SITE

NOTE:
AREAS DRAWN INDICATIVELY NOTED AND INDICATED BY GREY DASHED LINE AS LINE BELOW


LEVEL DATUM & ORIENTATION

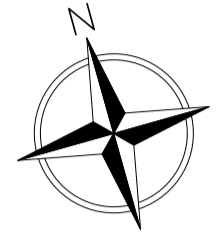

GEOGRAPHICAL ORIENTATION & NORTH POINT SHOWN ARE INDICATIVE ONLY.
ARBITRARY LEVELS CO-ORDINATED TO LOCAL STATIONS POSITIONED ON SITE DURING SURVEY.

ABBREVIATIONS & LEGEND:

LEVELS & HEIGHTS	SERVICES
CL - COVER LEVEL	BT - BRITISH TELECOMS
IL - INVERT LEVEL	CATV - CABLE TELEVISION
L - LEVEL	ER - EARTHING ROD
HT - HEIGHT	ES - ELECTRICAL SUPPLY
STN - SURVEY STATION	FH - FIRE HYDRANT
BH - BEAM	GAS - GAS SUPPLY
CE - CEILING	PO - POST OFFICE TELEPHONE
J - JOISTS	SV - STOP VALVE
RA - RAFTERS	TSSU - TRAFFIC LIGHT SIGNAL
E - EAVES	
FR - FLAT ROOF	
P - PARAPET	
F - FENCE	
U/S SF - UNDERSIDE OF SLAB	
R - RIDGE	
SL - SLAB	
SF - SOFFIT	
T - TREE	
THR - THRESHOLD	
To - TOP OF	
W - WALL	
HH - HEAD HEIGHT	
OH - OPENING HEIGHT	
SH - SILL HEIGHT	
GENERAL NOTES	
AB - ADVERTISING BOARD	
ACU - AIR CONDITIONING UNIT	
AU - AIR HANDLING UNIT	
AP - AIR PURIFIER	
ALP - ALARM PANEL	
B - BULLARD	
BA - BARRIER	
BE - BENCH	
BS - BUS STOP	
BU - BUIER	
BKO - BOXING OUT	
CAH - CEILING ACCESS HATCH	
CH - CHIMNEY	
CHD - CHIMNEY DOWNS	
CU - CURB	
DB - DOG WASTE BIN	
DW - DWELLING WALL	
DK - DROP KUB	
EDB - ELECTRICAL DISTRIBUTION BOARD	
EG - EXTRACTOR FLE	
EM - ELECTRIC METER	
FB - FUSE BOX	
FP - FIRE PLACE	
FU - FUSE	
FAP - FIRE ALARM PANEL	
GU - GUARDING	
GM - GAS METER	
HWC - HOT WATER CYLINDER	
LAM - LOFT ACCESS HATCH	
LB - LITTER BIN	
LP - LAMP POST	
PC - PAVING CROSSING	
PS - PAVING SLABS	
PL - PAVEMENT LIGHT	
FL - FLINTING	
PB - POST BOX	
RS - RAILING	
RS - ROAD SIGN	
SP - SPEED BUMP	
SG - SIGNAGE	
SN - STREET NAME SIGN	
SWD - SHOWER	
SHV - SHELVE	
TB - TELEPHONE BOX	
TL - TRAFFIC LIGHT	
TM - TICKET MACHINE	
TP - TELEGRAPH POLE	
VE - VEGETATION	
W - WATER	
WD - WARDROBE	
WH - WATER HEATER	
ZC - ZEBRA CROSSING	

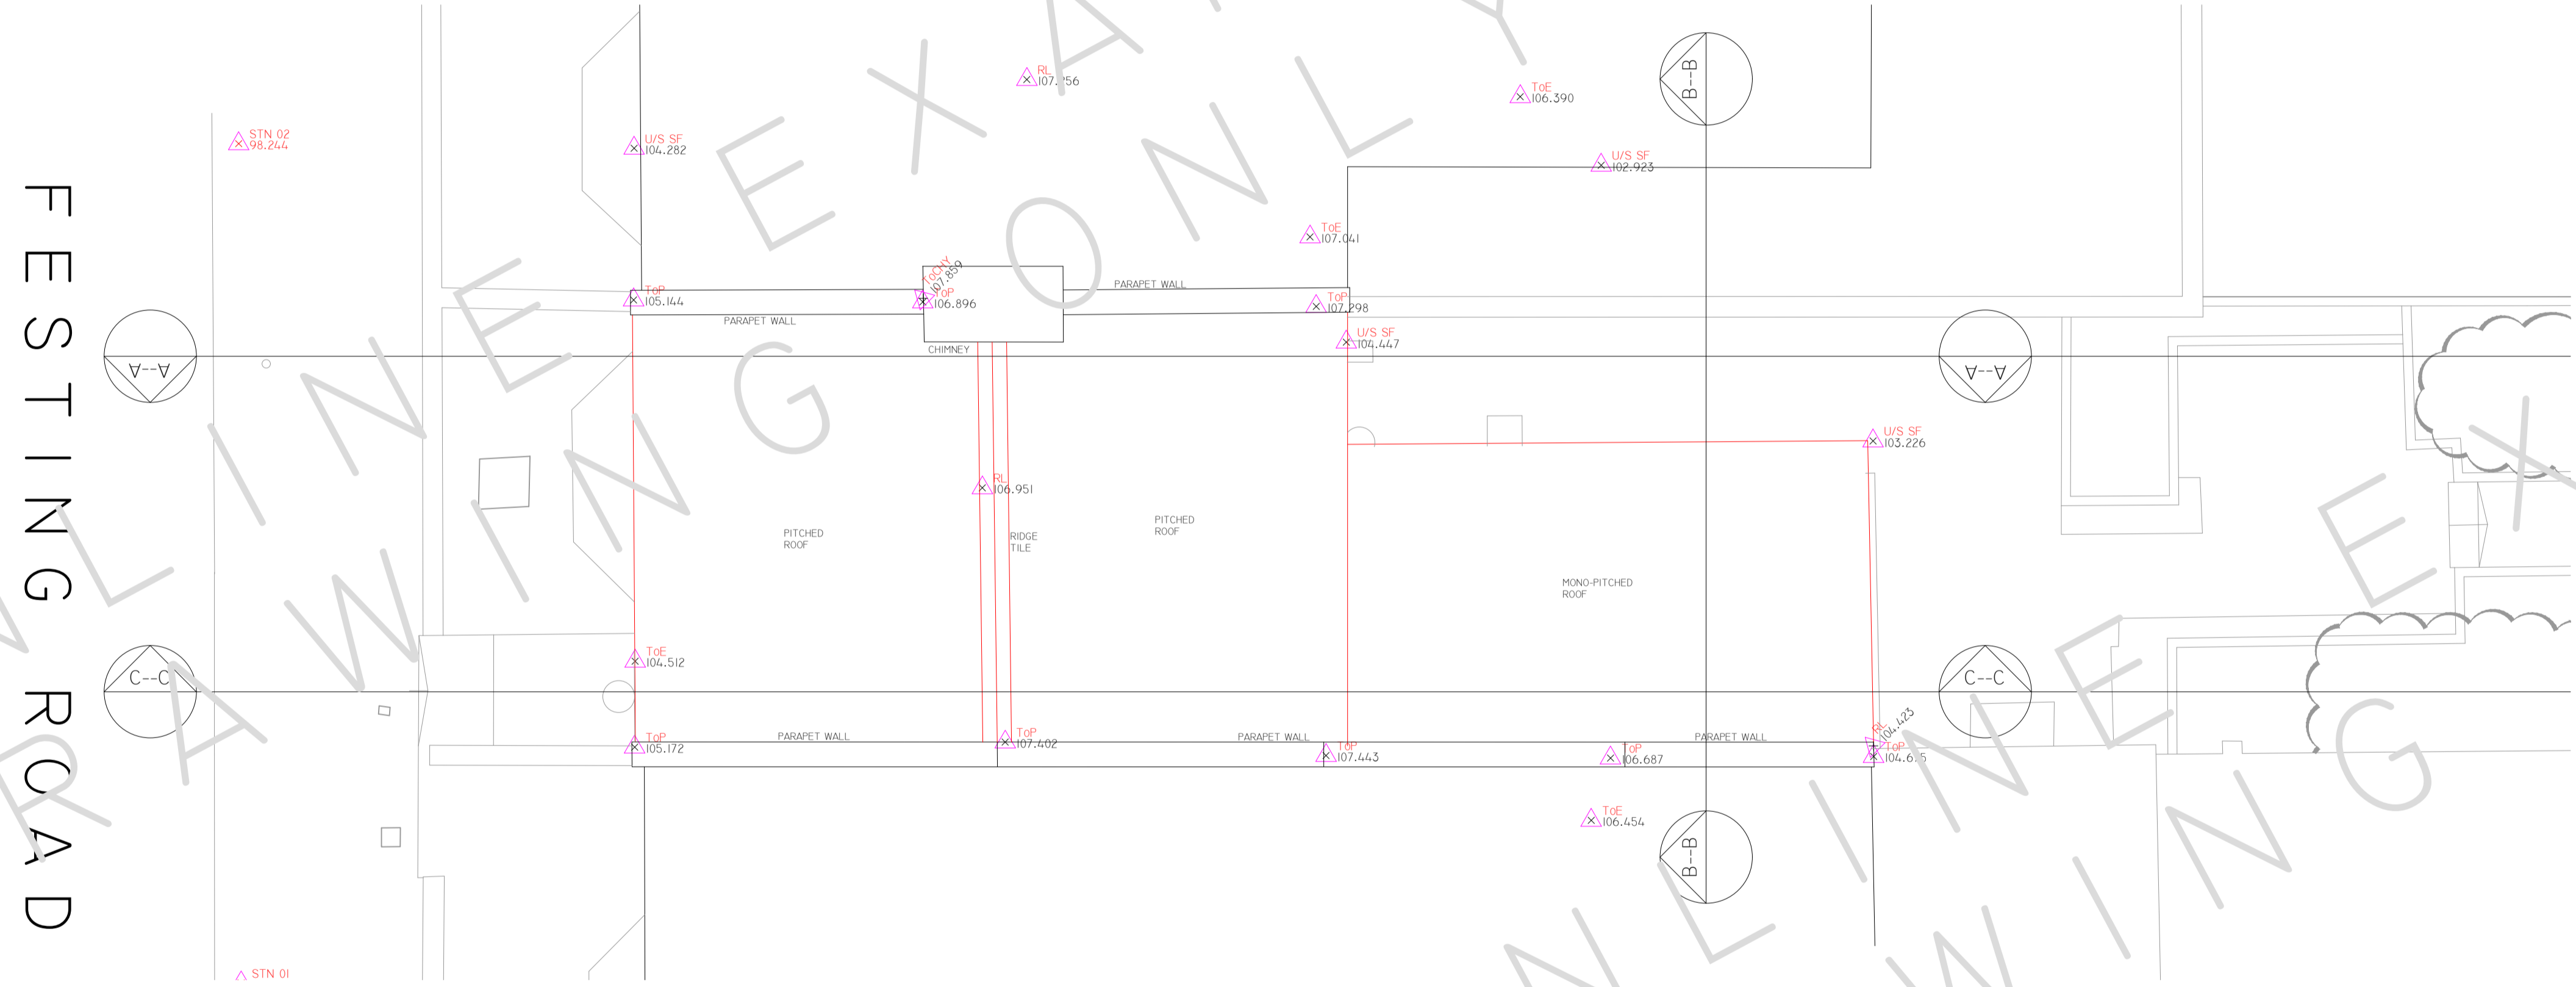

ROOF PLAN
1:50 SCALE

REV	DATE	AMENDMENTS


Mobile CAD Surveying office & on site

PROJECT: MEASURED BUILDING SURVEY
ADDRESS: 33 FESTING ROAD,

DWG NO.: 03
DWG TITLE: ROOF PLAN
DWG DATE: 2019
DWG SIZE: SCALE AS SHOWN @ A1
DRAWN: JH | CHECKED: JW


THIS DRAWING IS TO BE READ IN CONJUNCTION WITH ALL RELEVANT SPECIFICATIONS AND DRAWINGS ISSUED. FOR DISCREPANCIES OR OMISSIONS CONTACT MOBILE CAD SURVEYING SOLUTIONS LTD PRIOR TO WORK COMMENCING. THE CONTRACTOR IS TO CHECK AND VERIFY ALL BUILDING AND SITE DIMENSIONS AND LEVELS BEFORE WORK COMMENCES.
 © COPYRIGHT MOBILE CAD SURVEYING SOLUTIONS LTD 2019
 DO NOT SCALE THIS DRAWING - CHECK ALL DIMENSIONS ON SITE

NOTE:
 AREAS DRAWN INDICATIVELY NOTED AND INDICATED BY GREY DASHED LINE AS LINE BELOW

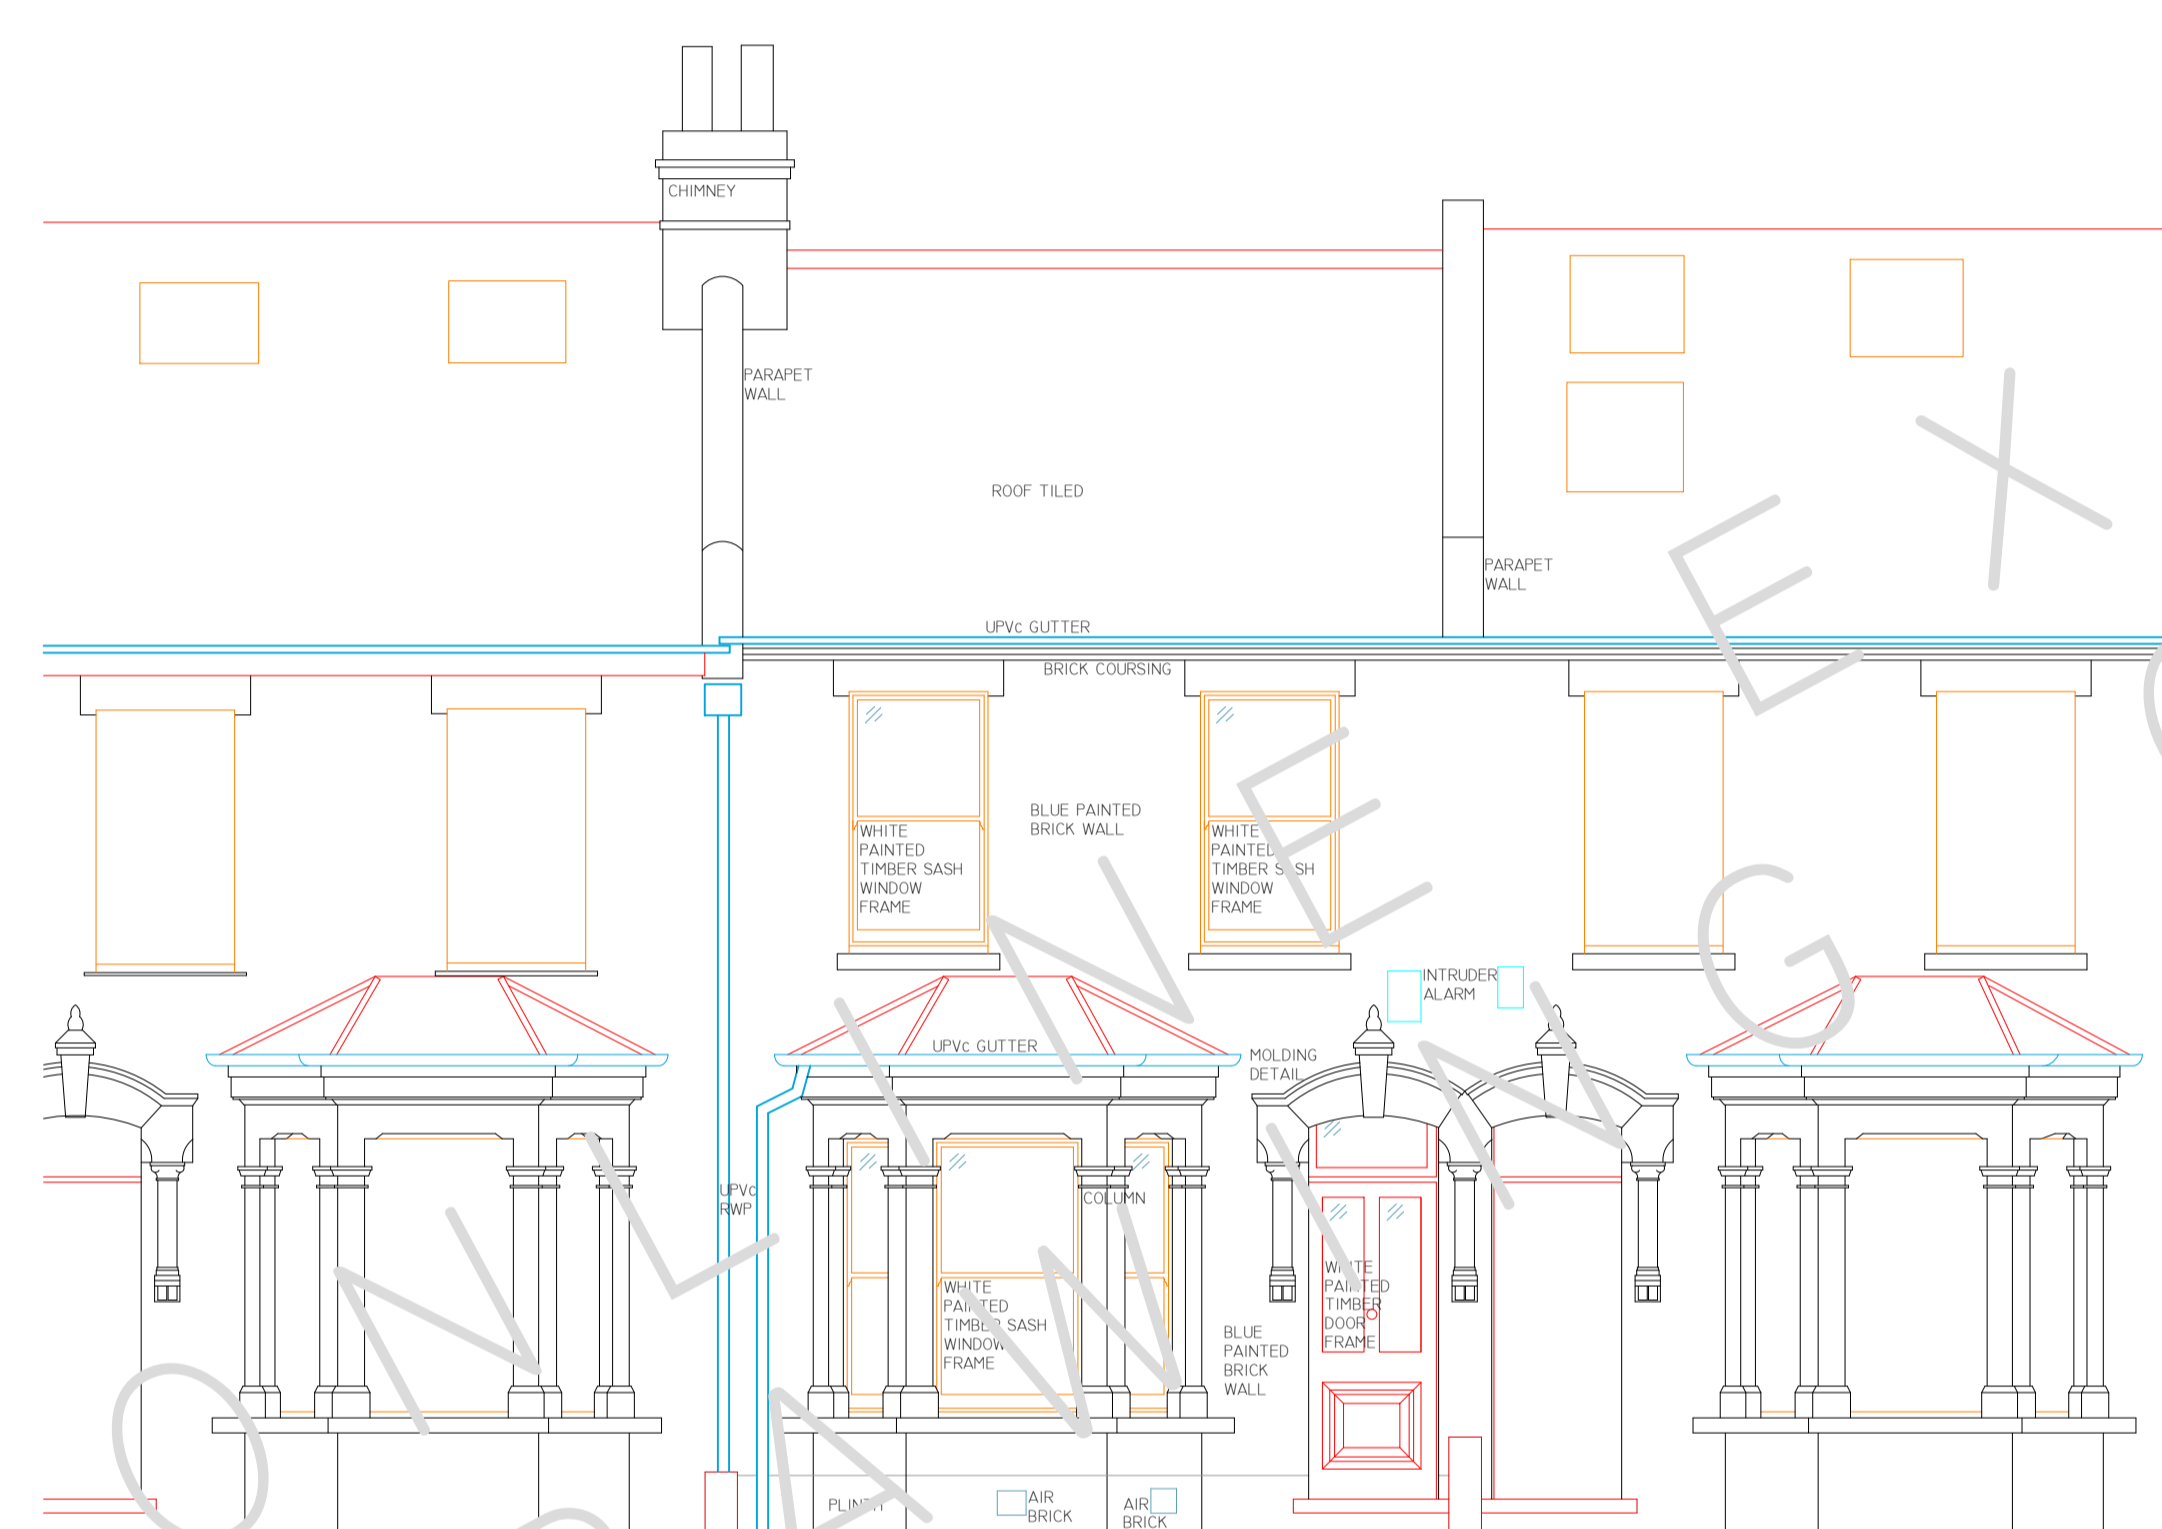

95M LINE

WEST ELEVATION
 1:50 SCALE

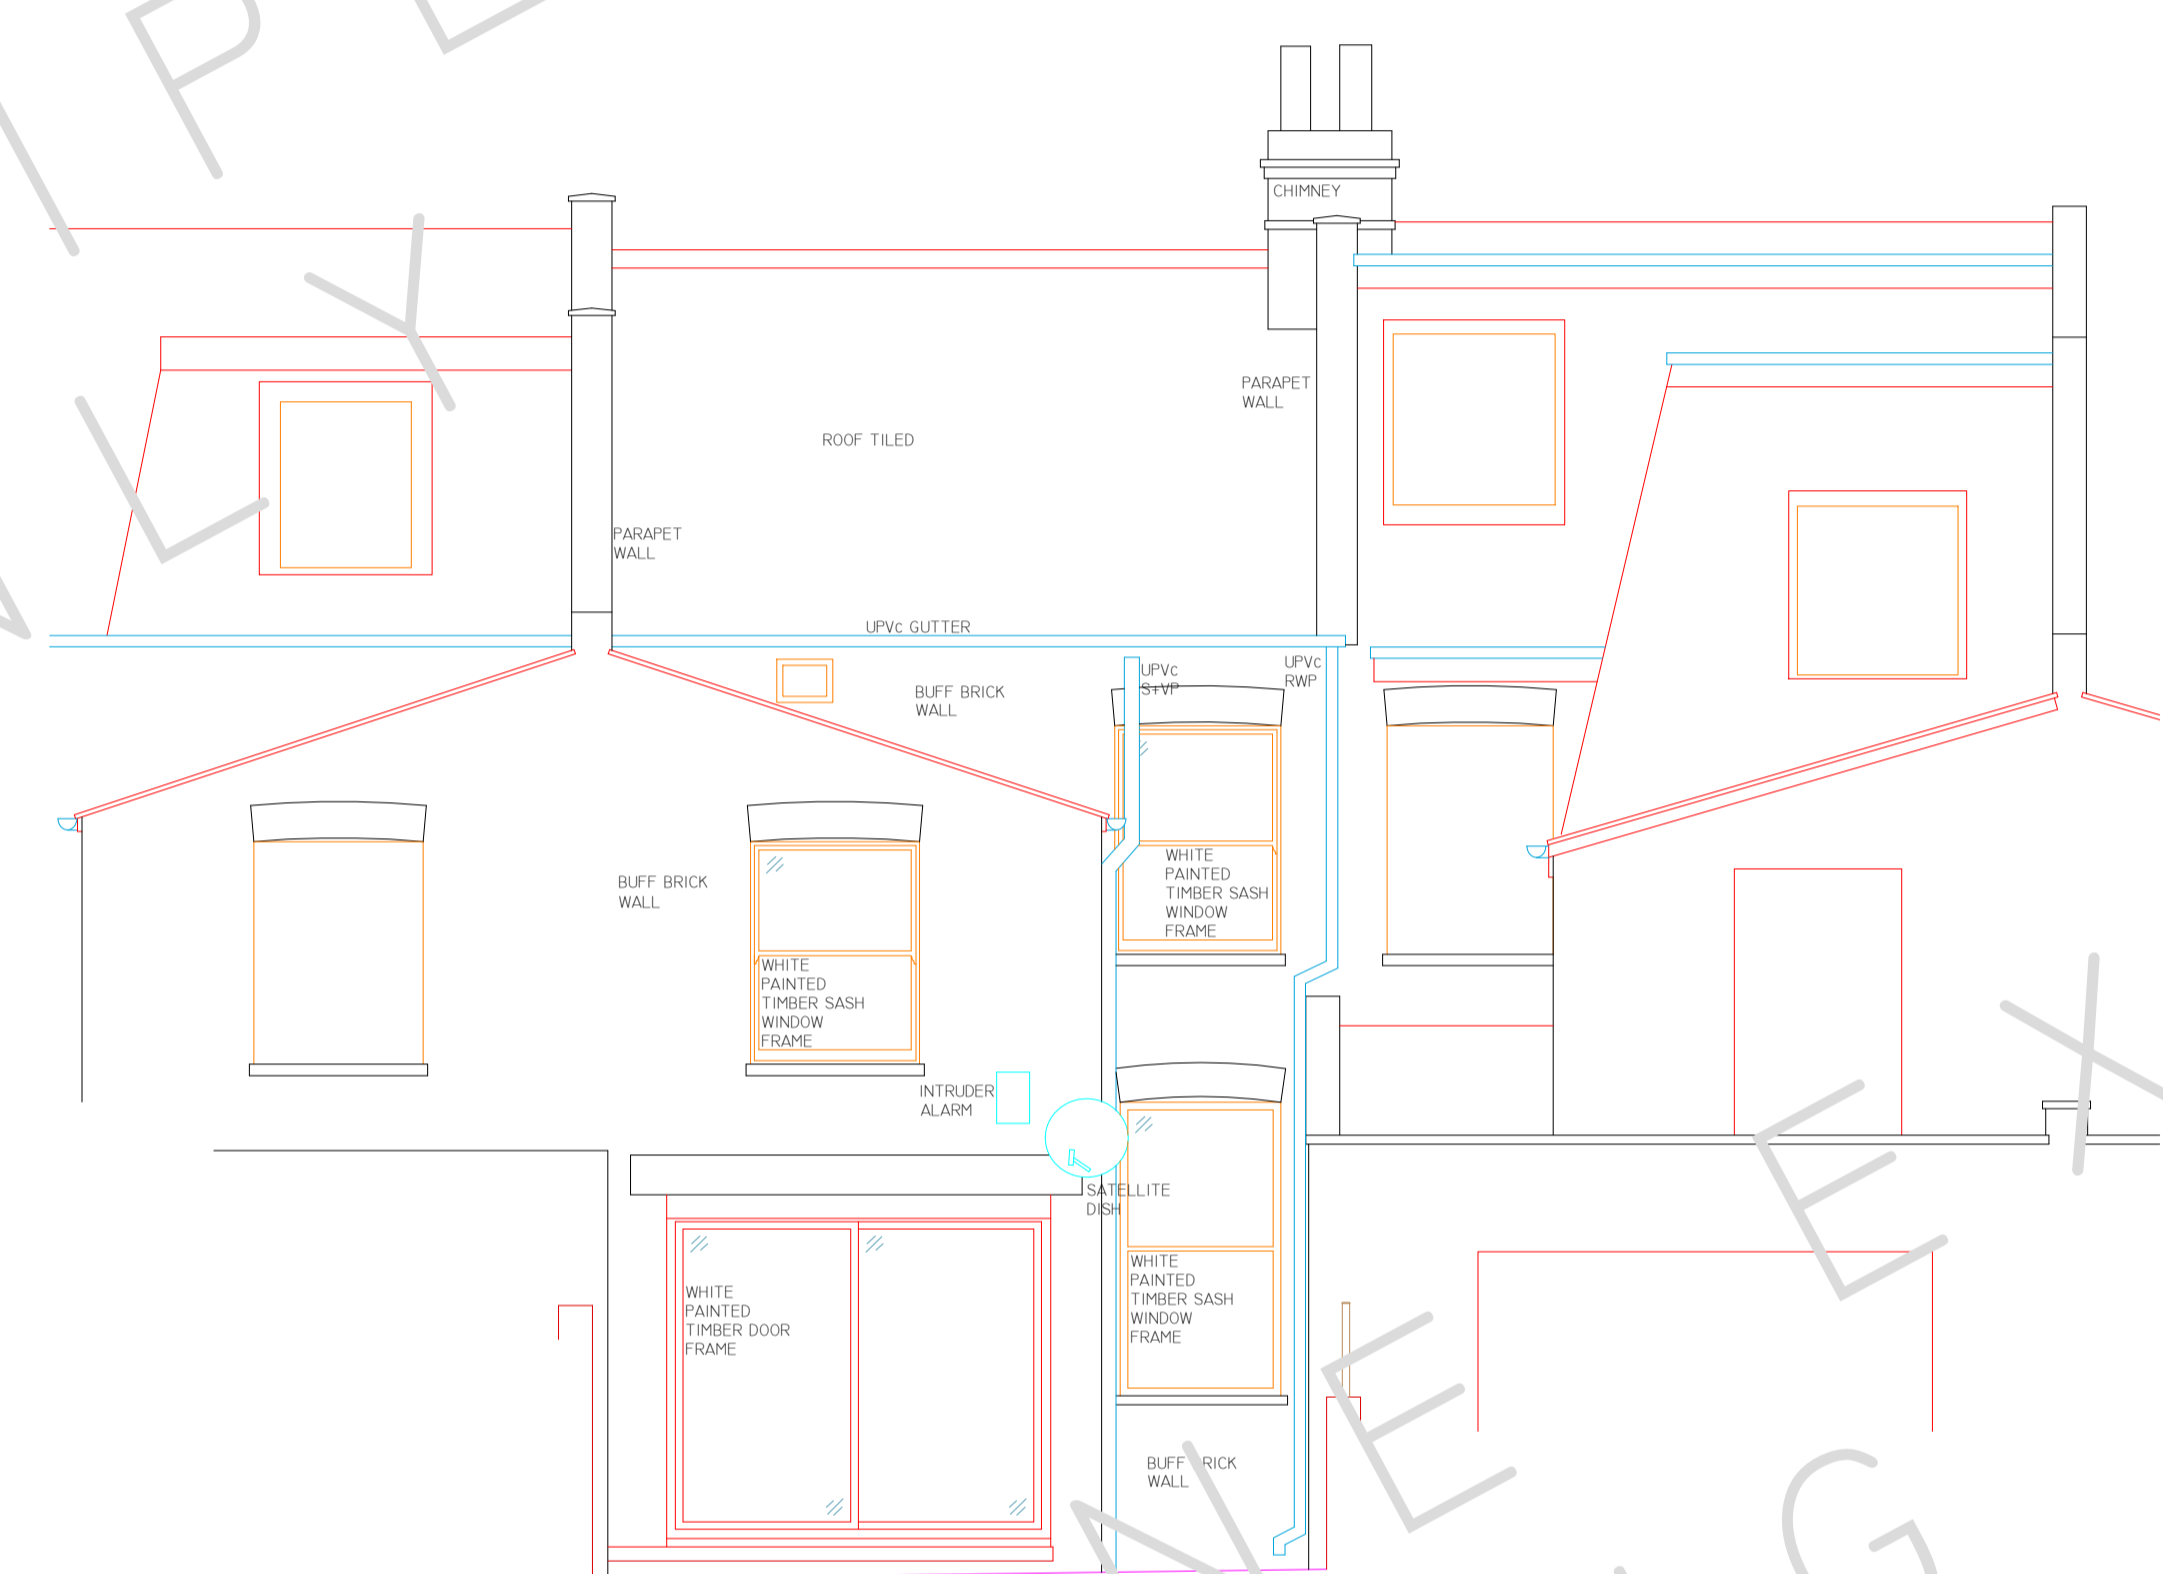


95M LINE

EAST ELEVATION
 1:50 SCALE


REV	DATE	AMENDMENTS

Mobile CAD Surveying office & on site


PROJECT: MEASURED BUILDING SURVEY
 ADDRESS: 33 FESTING ROAD,
 DWG NO.: 06
 DWG TITLE: ELEVATIONS
 DWG DATE: 2019
 DWG SIZE: SCALE AS SHOWN @ A1
 DRAWN: JH | CHECKED: JW | ISSUE: 1

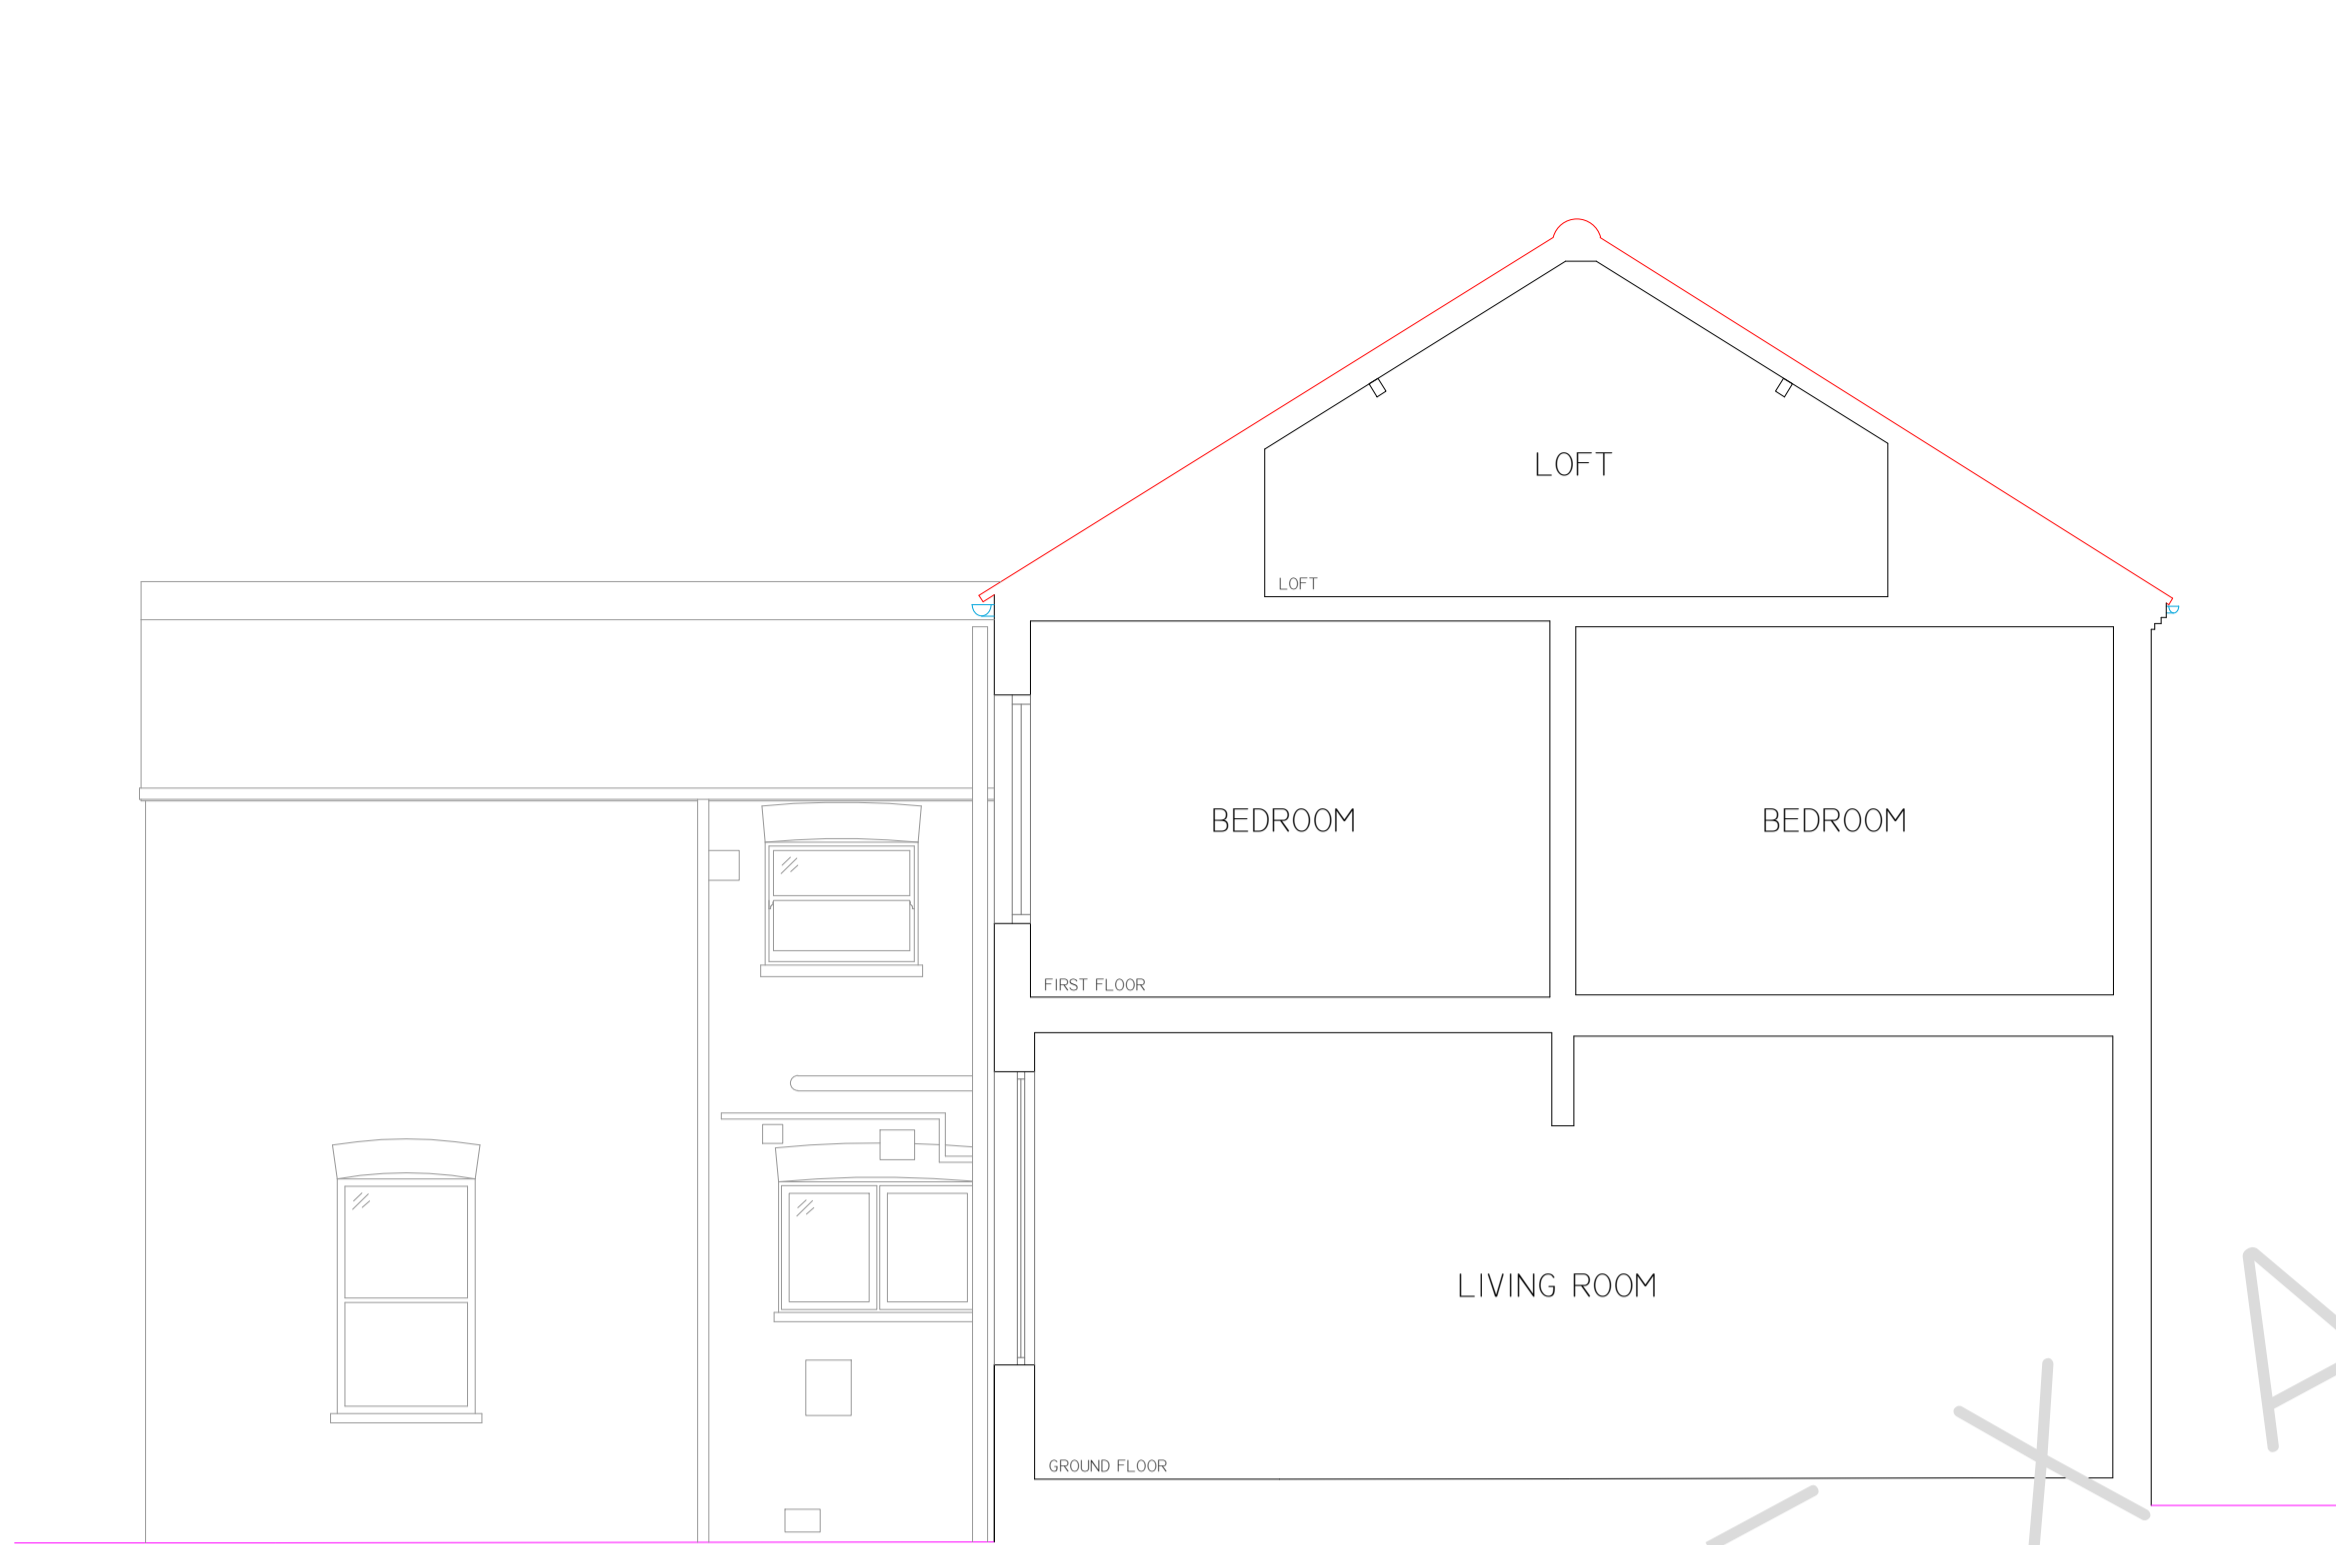

95M LINE
SECTION A--A
1:50 SCALE

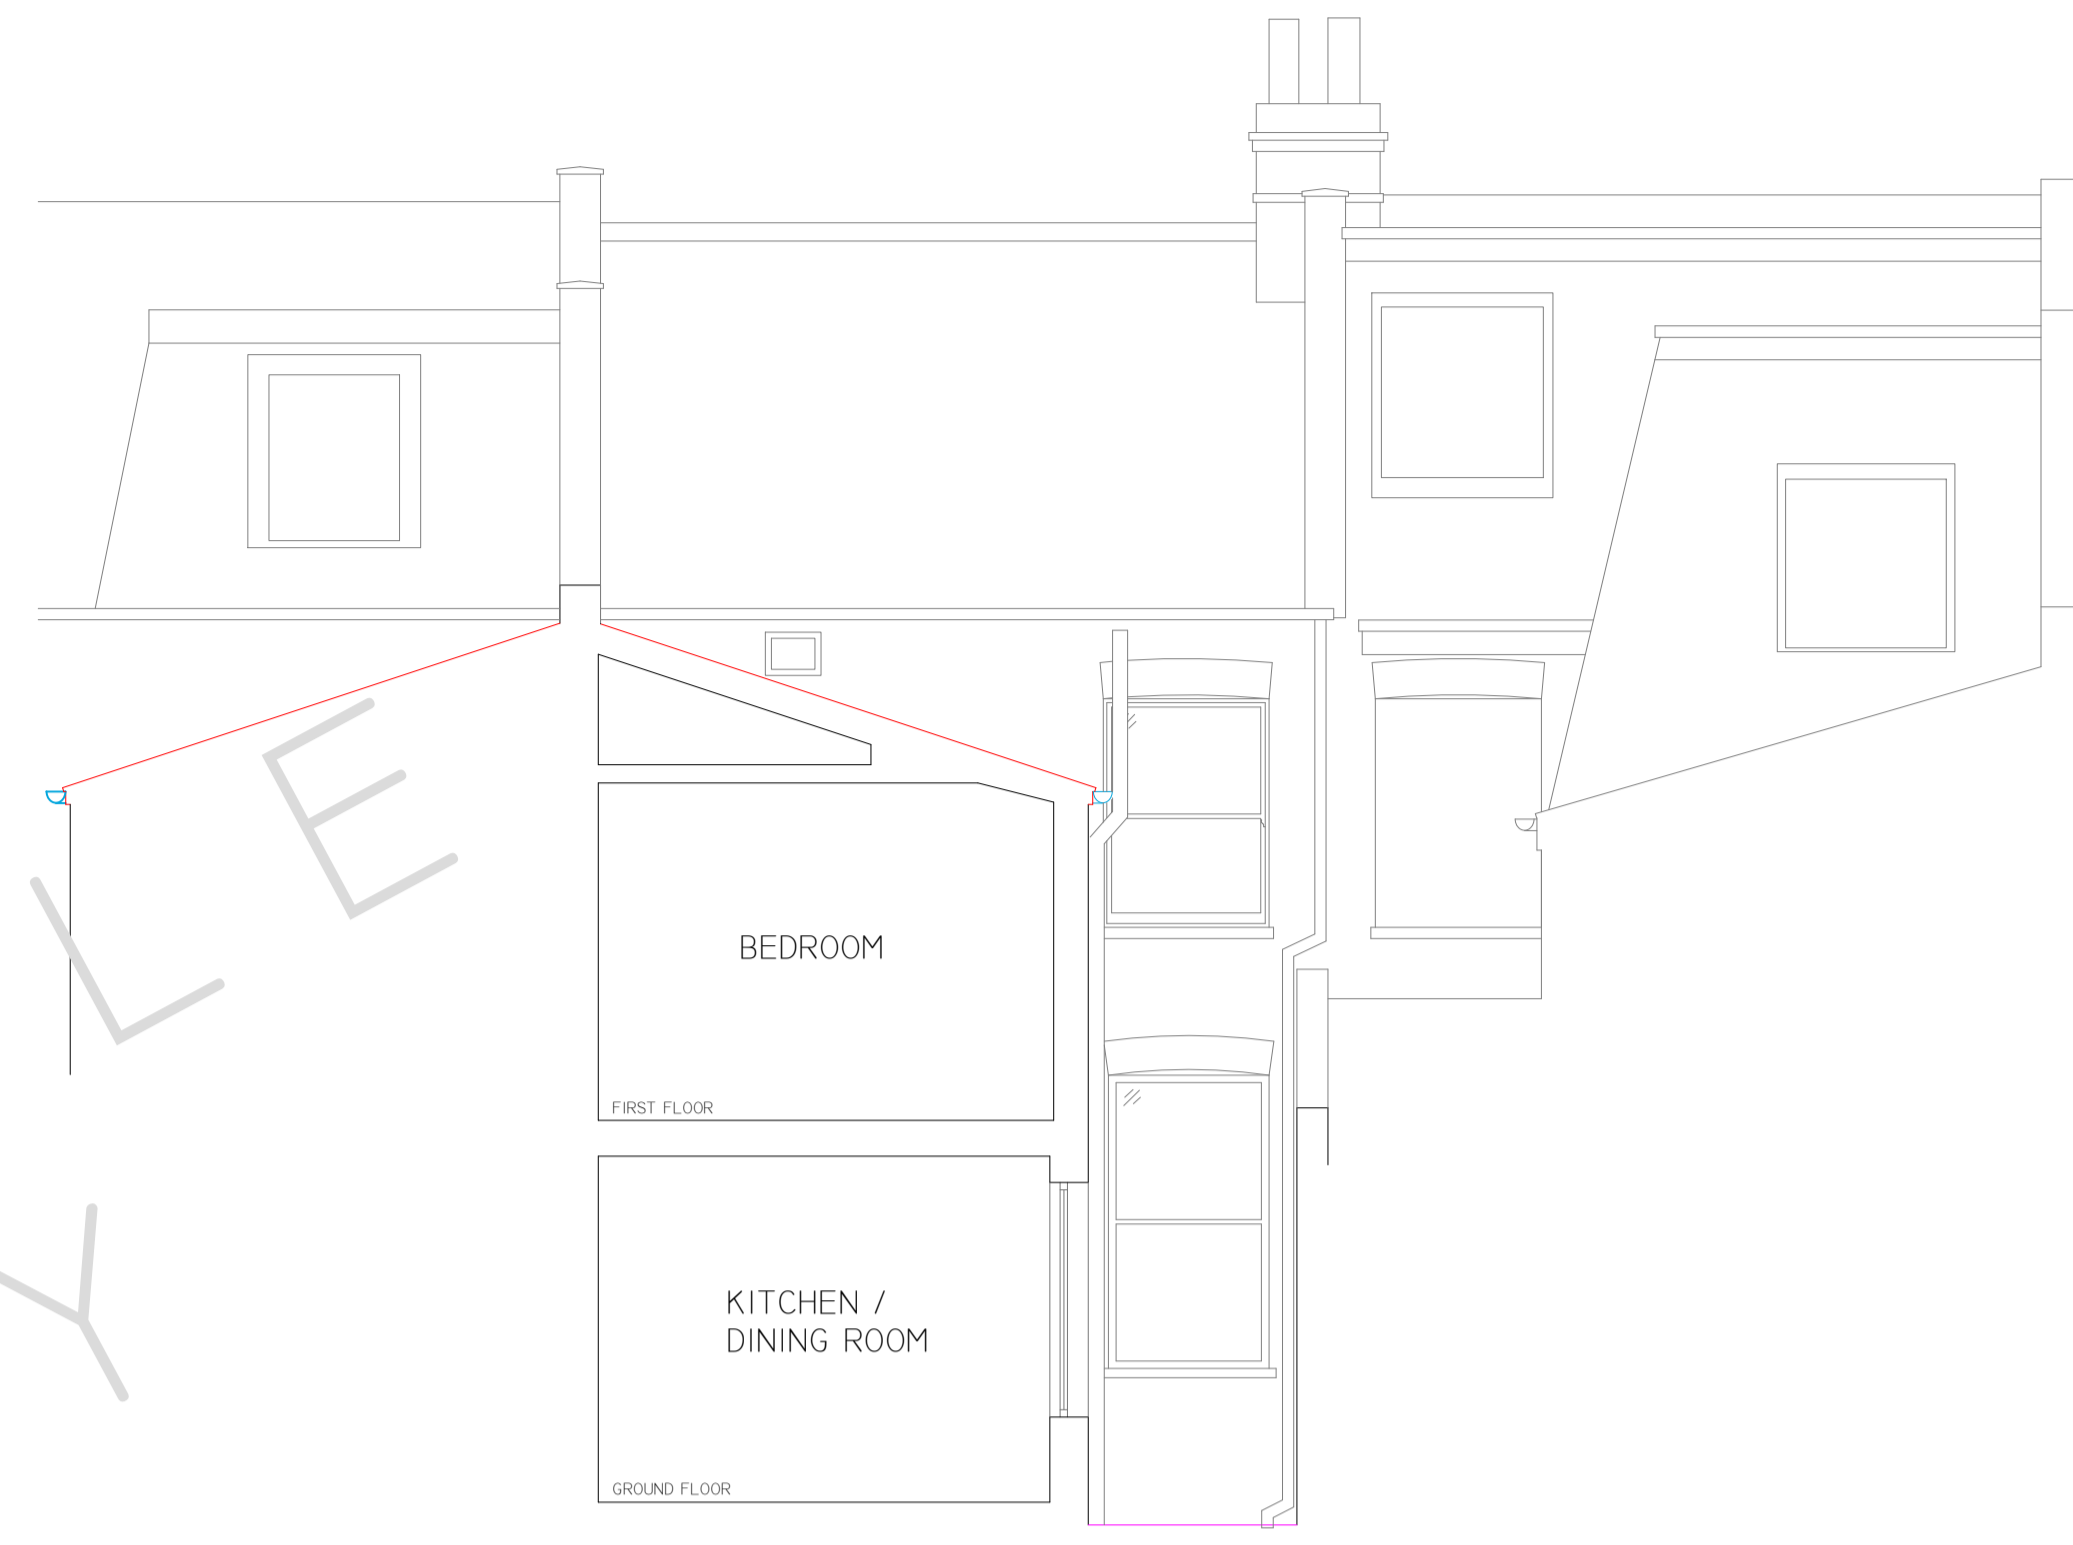

95M LINE
SECTION B--B
1:50 SCALE

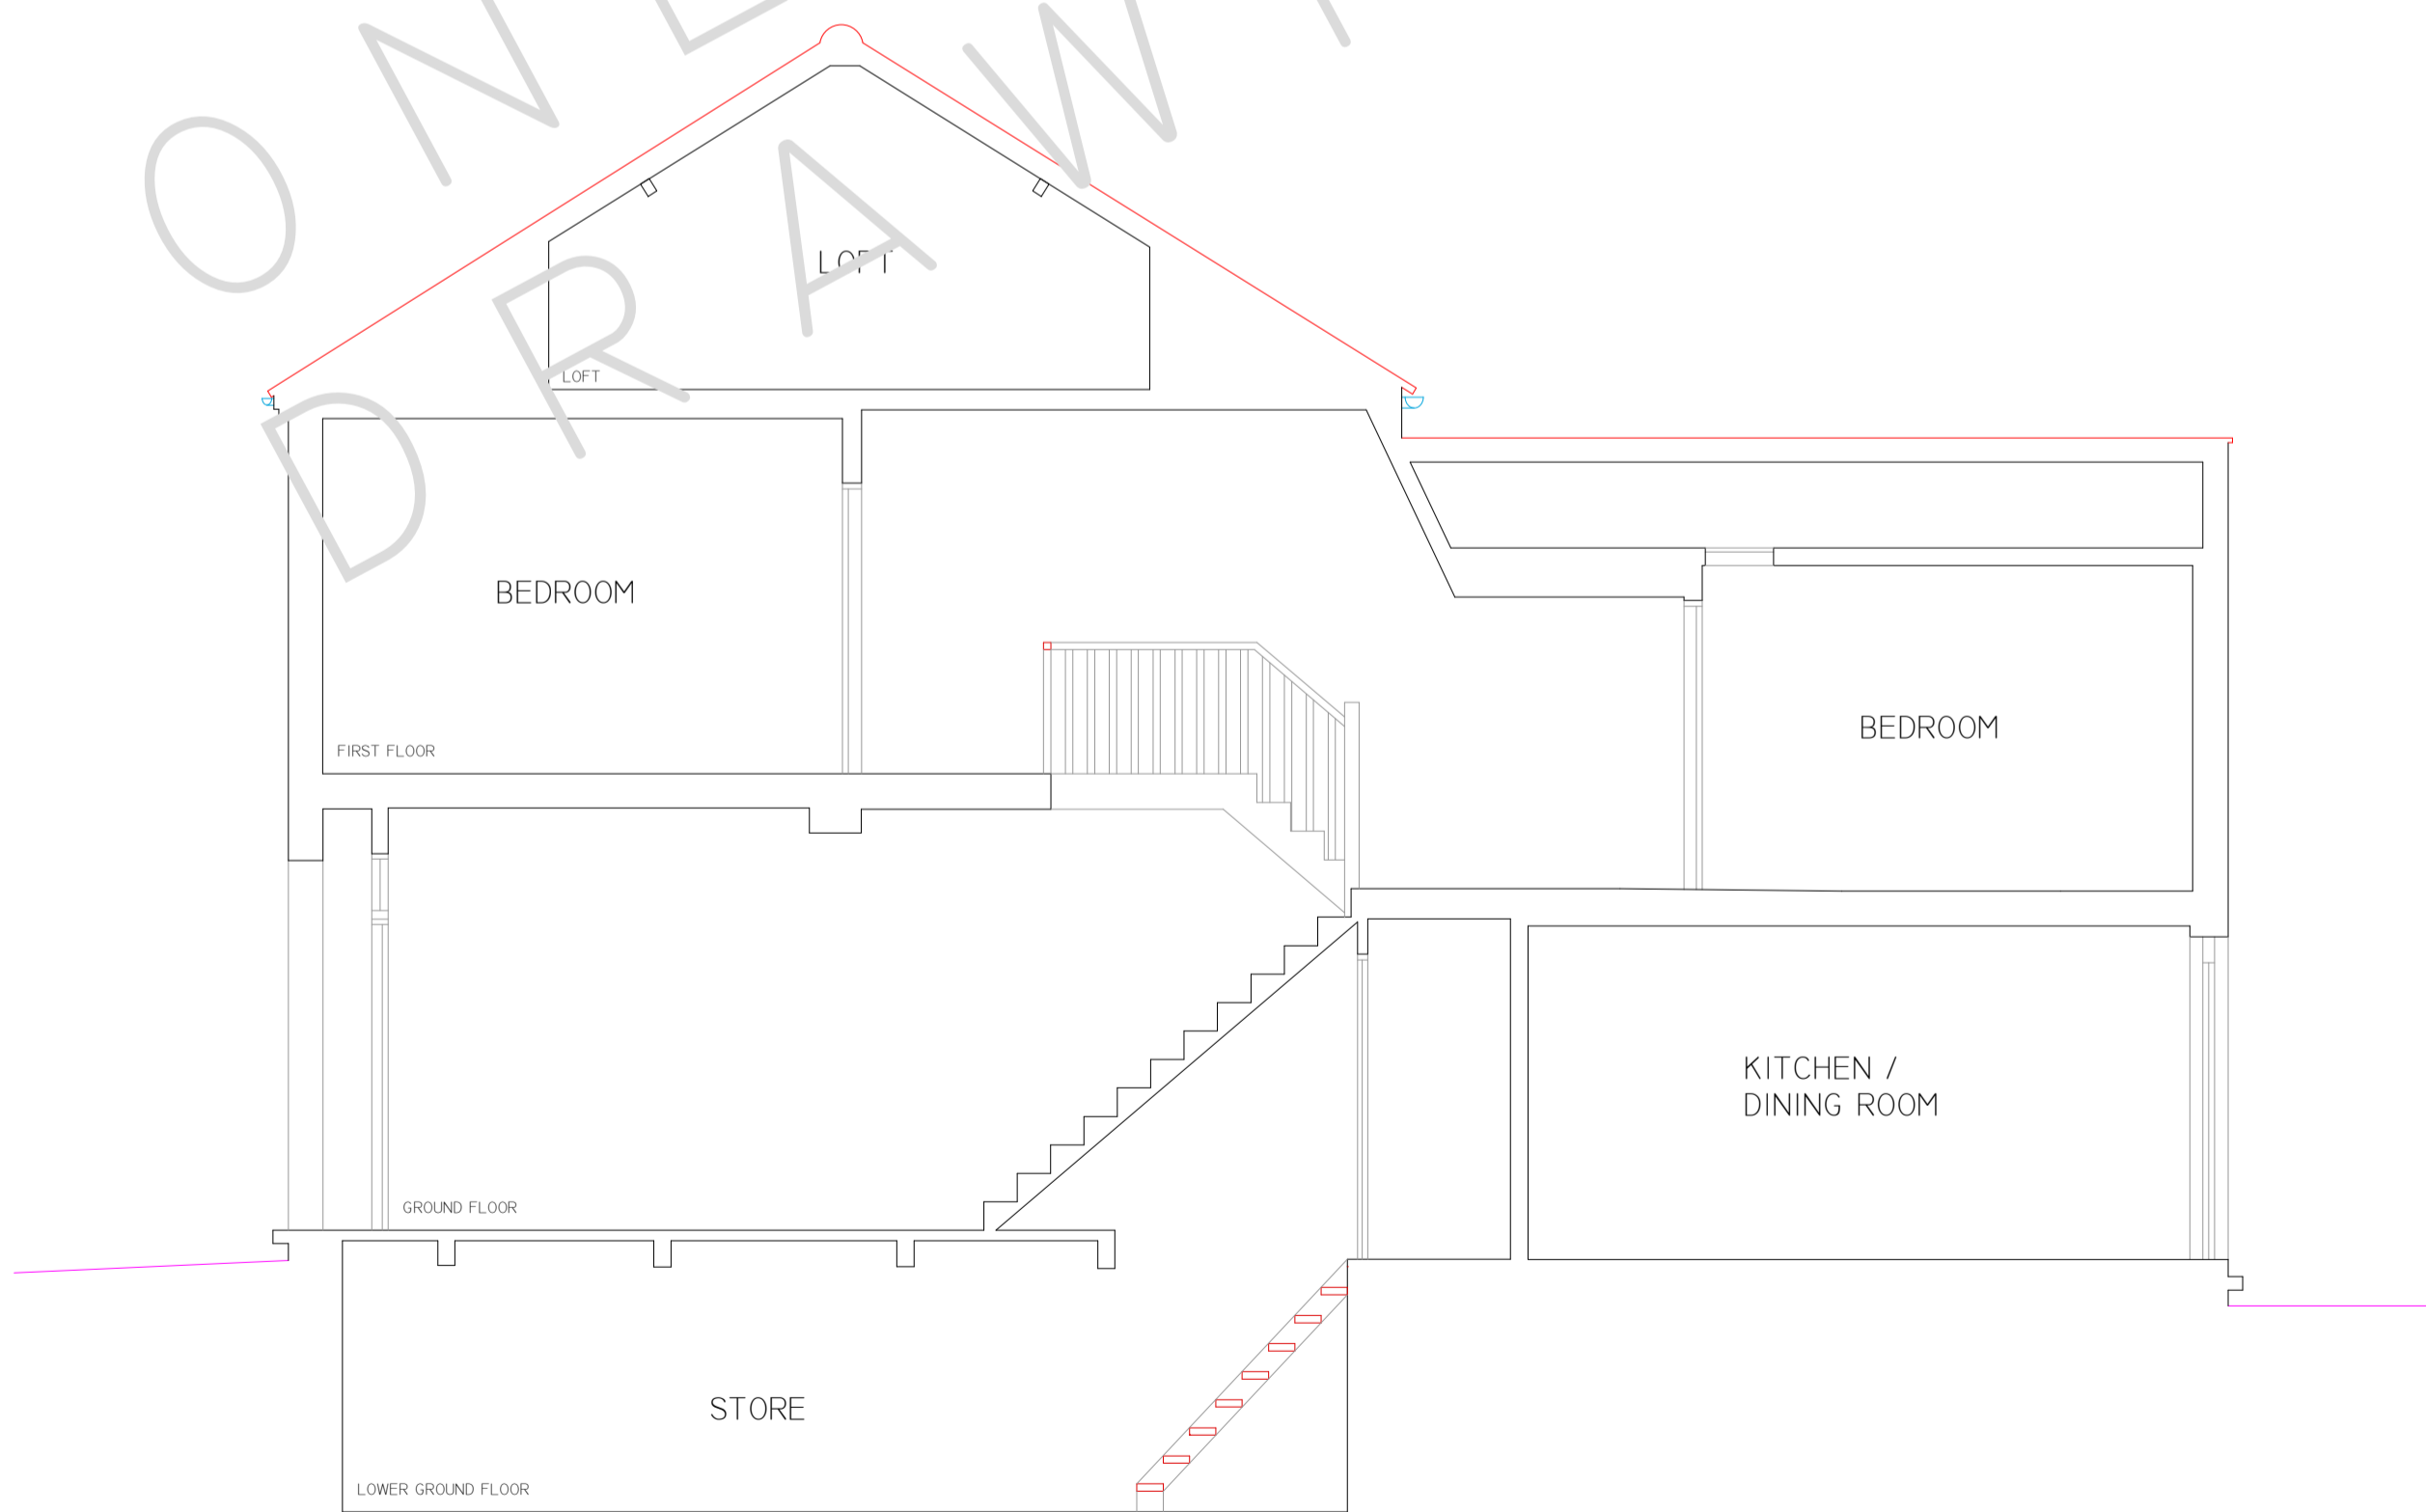


95M LINE
SECTION C--C
1:50 SCALE

THIS DRAWING IS TO BE READ IN CONJUNCTION WITH ALL RELEVANT SPECIFICATIONS AND DRAWINGS ISSUED. FOR DISCREPANCIES OR OMISSIONS CONTACT MOBILE CAD SURVEYING SOLUTIONS LTD PRIOR TO WORK COMMENCING. THE CONTRACTOR IS TO CHECK AND VERIFY ALL BUILDING AND SITE DIMENSIONS AND LEVELS BEFORE WORK COMMENCES.
© COPYRIGHT MOBILE CAD SURVEYING SOLUTIONS LTD 2019
DO NOT SCALE THIS DRAWING - CHECK ALL DIMENSIONS ON SITE

NOTE:
AREAS DRAWN INDICATIVELY NOTED AND INDICATED BY GREY DASHED LINE AS LINE BELOW

REV	DATE	AMENDMENTS



office & on site

www.mobilecad.co.uk

01273 810000

Unit 12, The Mill Lane, Littlehampton, West Sussex, PO16 1JG

01273 810000

PROJECT: MEASURED BUILDING SURVEY
ADDRESS: 33 FESTING ROAD,

DWG NO.: 05
DWG TITLE: SECTIONS
DWG DATE: 2019
DWG SIZE: SCALE AS SHOWN @ A1
DRAWN: JH | CHECKED: JW | ISSUE: 1