


CROFTON ROAD

THIS DRAWING IS TO BE READ IN CONJUNCTION WITH ALL RELEVANT SPECIFICATIONS AND DRAWINGS ISSUED. FOR DISCREPANCIES OR OMISSIONS CONTACT MOBILE CAD SURVEYING SOLUTIONS LTD PRIOR TO WORK COMMENCING. THE CONTRACTOR IS TO CHECK AND VERIFY ALL BUILDING AND SITE DIMENSIONS AND LEVELS BEFORE WORK COMMENCES.
 © COPYRIGHT MOBILE CAD SURVEYING SOLUTIONS LTD 2018
 DO NOT SCALE THIS DRAWING - CHECK ALL DIMENSIONS ON SITE

NOTE:
 AREAS DRAWN INDICATIVELY NOTED AND INDICATED BY GREY DASHED LINE AS LINE BELOW

LEVEL DATUM & ORIENTATION

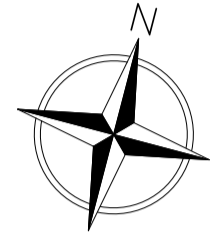


GEOGRAPHICAL ORIENTATION & NORTH POINT SHOWN ARE INDICATIVE ONLY.
 ARBITRARY LEVELS CO-ORDINATED TO LOCAL STATIONS POSITIONED ON SITE DURING SURVEY.

ABBREVIATIONS & LEGEND:

LEVELS & HEIGHTS	SURVICES
CL - COVER LEVEL	BT - BRITISH TELECOMS
IL - INVERT LEVEL	CATV - CABLE TELEVISION
L - LEVEL	ER - EARTHING ROD
HT - HEIGHT	ES - ELECTRICAL SUPPLY
STN - SURVEY STATION	FH - FIRE HYDRANT
BM - BENCH	GS - GAS SUPPLY
CE - CEILING	PO - POST OFFICE TELEPHONE
CS - CISTS	SV - STOP VALVE
RA - RAFTERS	TSU - TRAFFIC LIGHT SIGNAL
FR - FLAT ROOF	
P - PARAPET	DRAINAGE
F - FENCE	DC - DRAINAGE CHANNEL
US - UNDERSIDE OF	G - GULLY
R - RIDGE	I - INSPECTION CHAMBER
SL - SLAB	M - MANHOLE
SF - SOFFIT	RE - RIDDING EYE
T - TREE	RWP - RAIN WATER PIPE
THR - THRESHOLD	UTL - UNABLE TO PLT
TO - TOP OF	SWP - SOIL/WATER PIPE
W - WALL	ST - STOP TAP
HH - HEAD HEIGHT	WM - WATER METER
OH - OPENING HEIGHT	
SH - SILL HEIGHT	TYPICAL DRAWING SYMBOLS
GENERAL NOTES	SPOT LEVEL X 96.256
AB - ADVERTISING BOARD	SPOT HEIGHT X 99.034
AC - AIR CONDITIONING UNIT	
AU - AIR HANDLING UNIT	
AP - ALARMS ALARM PANEL	
B - BULL LARD	
BA - BARRIER	
BE - BENCH	
BS - BUS STOP	
BU - BUS	
BXD - BOXING OUT	
CAH - CEILING ACCESS HATCH	
CHY - CHIMNEY	
CPD - CLIPBOARD	
DB - DOG WASTE BIN	
DW - DWELL WALL	
DK - DROP KUBES	
EDB - ELECTRICAL DISTRIBUTION BOARD	
EG - EXTRACT TUBULE	
EM - ELECTRIC METER	
FB - FUSE BOX	
FI - FIREPLACE	
FL - FLOOR	
FAP - FIRE ALARM PANEL	
GU - GUARDING	
GM - GAS METER	
HWC - HOT WATER CYLINDER	
LAM - LOFT ACCESS HATCH	
LB - LITTER BIN	
LP - LAMP POST	
PC - PELICAN CROSSING	
PS - PAVING SLABS	
PL - PAVEMENT LIGHT	
PLT - PLANTING	
PB - POST BOX	
RS - RAILING	
RS - ROAD SIGN	
SP - SPEED BUMP	
SG - SIGNAGE	
SN - STREET NAME SIGN	
SWR - SHOWER	
SHV - SHELVING	
TB - TELEPHONE BOX	
TL - TRAFFIC LIGHT	
TM - TICKET MACHINE	
TP - TELEGRAPH POLE	
W - WATER	
WD - WARDROBE	
WH - WATER HEATER	
ZC - ZEBRA CROSSING	

GROUND FLOOR PLAN
 1:50 SCALE

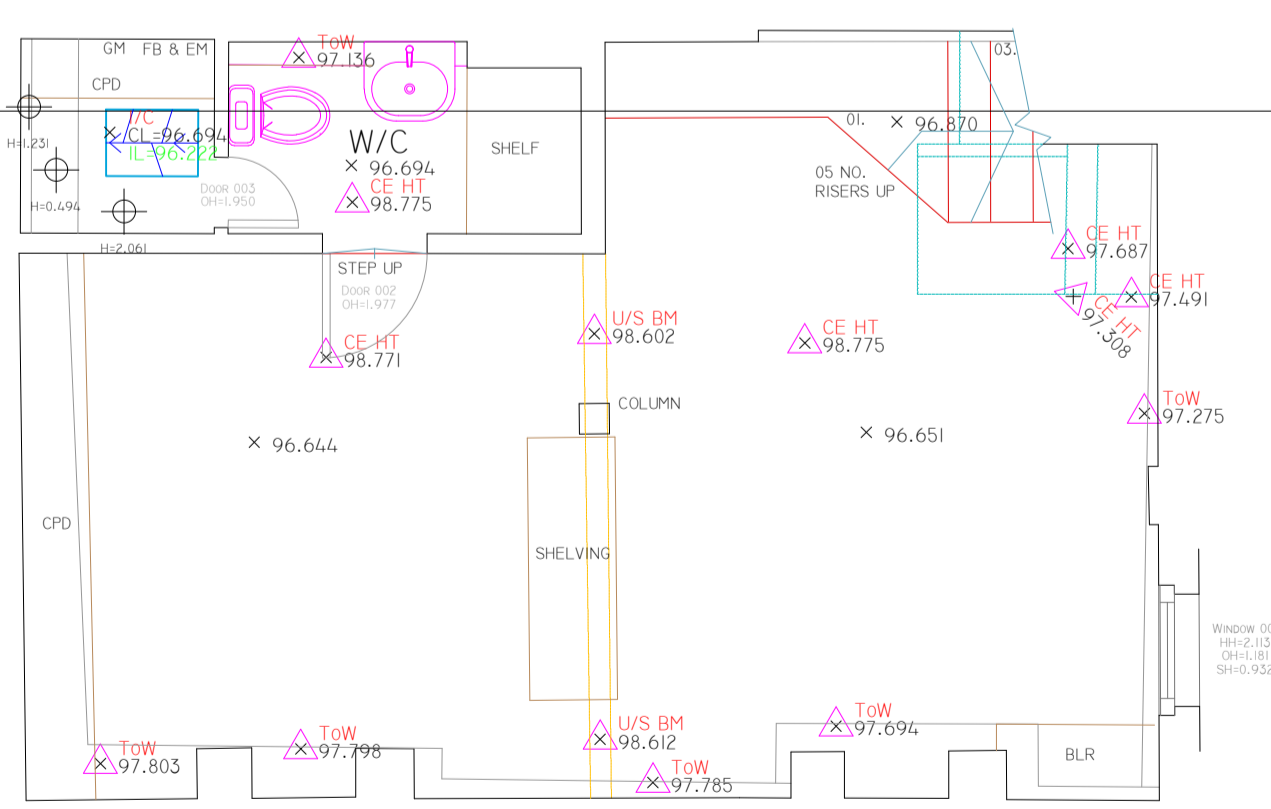

REV	DATE	AMENDMENTS

Mobile CAD Surveying office & on site

PROJECT: MEASURED BUILDING SURVEY
 ADDRESS: 87 CROFTON ROAD

DWG NO.: 01
 DWG TITLE: LOWER & GROUND FLOOR PLAN
 DWG DATE: 2018
 DWG SIZE: SCALE AS SHOWN @ A1
 DRAWN: JW | CHECKED: MW | ISSUE: 1

LOWER GROUND FLOOR PLAN
 1:50 SCALE

CROFTON ROAD

FIRST FLOOR PLAN
1:50 SCALE


CROFTON ROAD

LOWER FIRST FLOOR PLAN
1:50 SCALE



THIS DRAWING IS TO BE READ IN CONJUNCTION WITH ALL RELEVANT SPECIFICATIONS AND DRAWINGS ISSUED. FOR DISCREPANCIES OR OMISSIONS CONTACT MOBILE CAD SURVEYING SOLUTIONS LTD PRIOR TO WORK COMMENCING. THE CONTRACTOR IS TO CHECK AND VERIFY ALL BUILDING AND SITE DIMENSIONS AND LEVELS BEFORE WORK COMMENCES.
© COPYRIGHT MOBILE CAD SURVEYING SOLUTIONS LTD 2018
DO NOT SCALE THIS DRAWING - CHECK ALL DIMENSIONS ON SITE

NOTE:
AREAS DRAWN INDICATIVELY NOTED AND INDICATED BY GREY DASHED LINE AS LINE BELOW

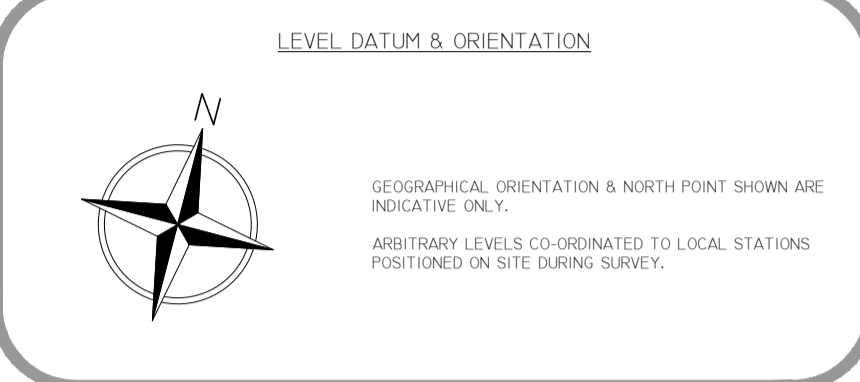

ABBREVIATIONS & LEGEND:

LEVELS & HEIGHTS	SERVICES
CL - COVER LEVEL	BT - BRITISH TELECOMS
IL - INVERT LEVEL	CATV - CABLE TELEVISION
L - LEVEL	ER - EARTHING ROD
HT - HEIGHT	ES - ELECTRICAL SUPPLY
STN - SURVEY STATION	FH - FIRE HYDRANT
BM - BENCH	GAS - GAS SUPPLY
CE - CEILING	PO - POST OFFICE TELEPHONE
J - JOISTS	SV - STOP VALVE
RA - RAFTERS	TSU - TRAFFIC LIGHT SIGNAL
E - EAVES	
FR - FLAT ROOF	
P - PARAPET	
F - FENCE	
US - UNDERSIDE OF	
R - RIDGE	
SL - SLAB	
SF - SOFFIT	
T - TREE	
THR - THRESHOLD	
To - TOP OF	
W - WALL	
HH - HEAD HEIGHT	
OH - OPENING HEIGHT	
SH - SILL HEIGHT	
GENERAL NOTES	
AB - ADVERTISING BOARD	
ACU - AIR CONDITIONING UNIT	
AHU - AIR HANDLING UNIT	
AP - ALARM PANEL	
B - BULLARD	
BA - BARRIER	
BE - BENCH	
BS - BUS STOP	
BU - BUIER	
BXG - BOXING OUT	
CAH - CEILING ACCESS HATCH	
CH - CHIMNEY	
CHD - CHIMNEY	
DB - DOG WASTE BIN	
DW - DWELLING WALL	
DK - DROP KUBER	
EDB - ELECTRICAL DISTRIBUTION BOARD	
EG - EXTRACT FURLE	
M - ELECTRIC METER	
FB - FUSE BOX	
FP - FIREPLACE	
FU - FUSE	
FAP - FIRE ALARM PANEL	
GU - GUARDING	
GM - GAS METER	
HWC - HOT WATER CYLINDER	
LAM - LOFT ACCESS HATCH	
LB - LITTER BIN	
LP - LAMP POST	
PC - PAVING CROSSING	
PS - PAVING SLABS	
PL - PAVEMENT LIGHT	
PLT - PLANTING	
PB - POST BOX	
RS - RAILING	
RS - ROAD SIGN	
SP - SPEED BUMP	
SG - SIGNAGE	
SN - STREET NAME SIGN	
SWR - SWIRL	
SHV - SHELVE	
TB - TELEPHONE BOX	
TL - TRAFFIC LIGHT	
TM - TICKET MACHINE	
TP - TELEGRAPH POLE	
W - WATER	
WD - WARDROBE	
WH - WATER HEATER	
ZC - ZEBRA CROSSING	

REV	DATE	AMENDMENTS

PROJECT: MEASURED BUILDING SURVEY
ADDRESS: 87 CROFTON ROAD,

DWG NO.: 02
DWG TITLE: LOWER & FIRST FLOOR PLAN
DWG DATE: 2018
DWG SIZE: SCALE AS SHOWN @ A1
DRAWN: JW | CHECKED: MW | ISSUE: 1

THIS DRAWING IS TO BE READ IN CONJUNCTION WITH ALL RELEVANT SPECIFICATIONS AND DRAWINGS ISSUED. FOR DISCREPANCIES OR OMISSIONS CONTACT MOBILE CAD SURVEYING SOLUTIONS LTD PRIOR TO WORK COMMENCING. THE CONTRACTOR IS TO CHECK AND VERIFY ALL BUILDING AND SITE DIMENSIONS AND LEVELS BEFORE WORK COMMENCES.


© COPYRIGHT MOBILE CAD SURVEYING SOLUTIONS LTD 2018

DO NOT SCALE THIS DRAWING - CHECK ALL DIMENSIONS ON SITE

NOTE:
AREAS DRAWN INDICATIVELY NOTED AND INDICATED BY GREY DASHED LINE AS LINE BELOW




WEST ELEVATION
1:50 SCALE

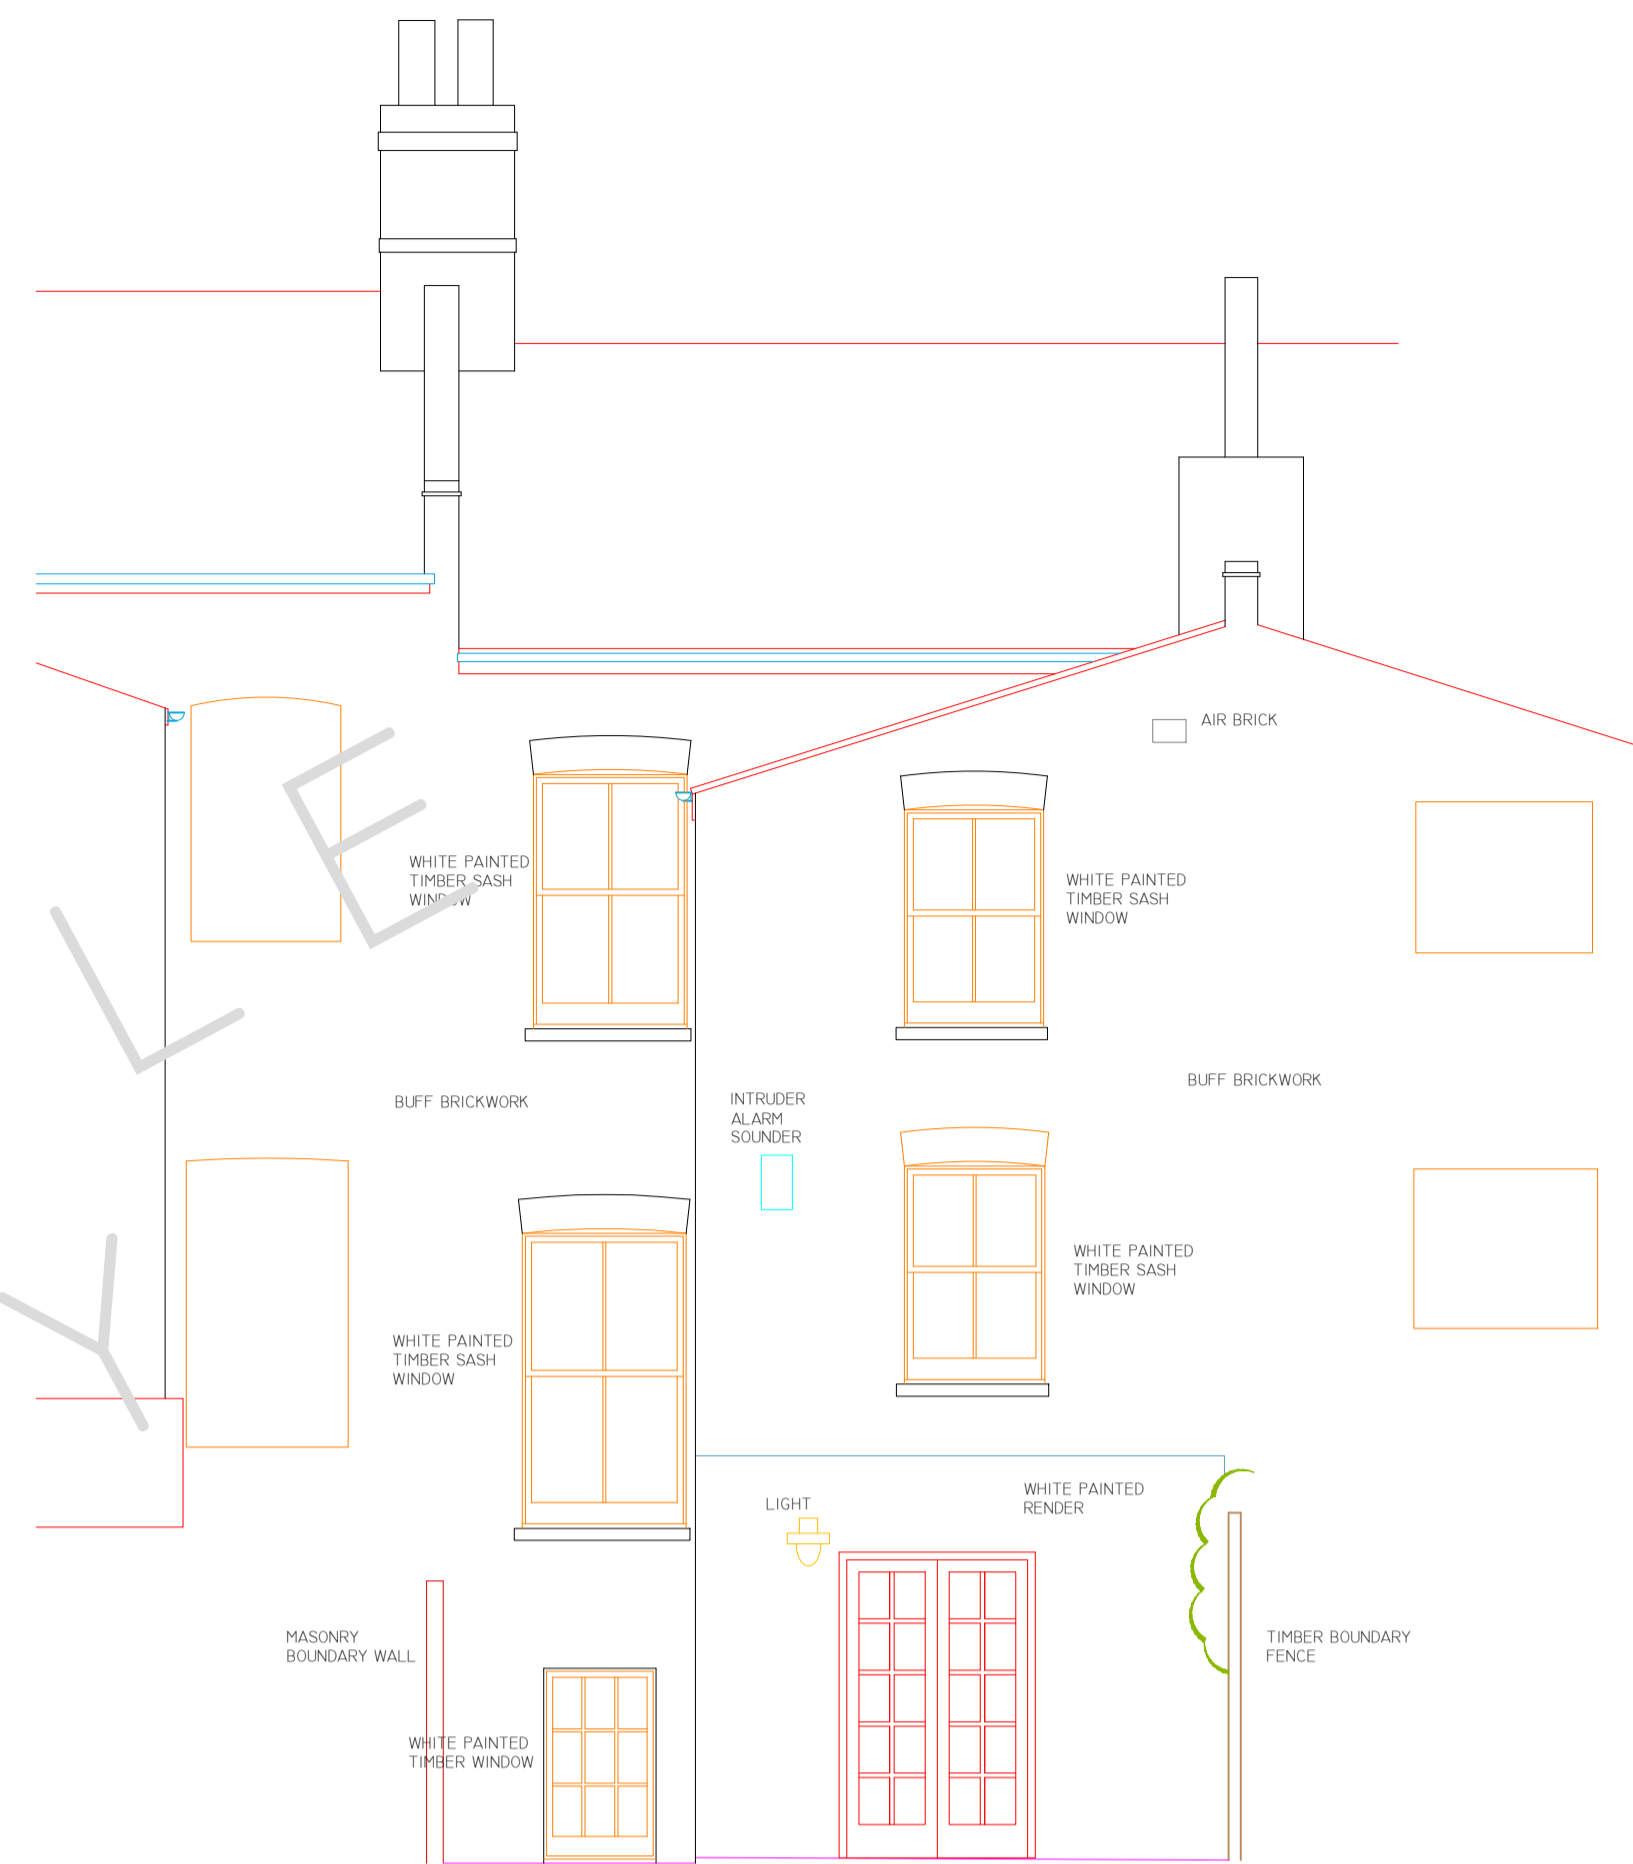

EAST ELEVATION
1:50 SCALE

95M LINE

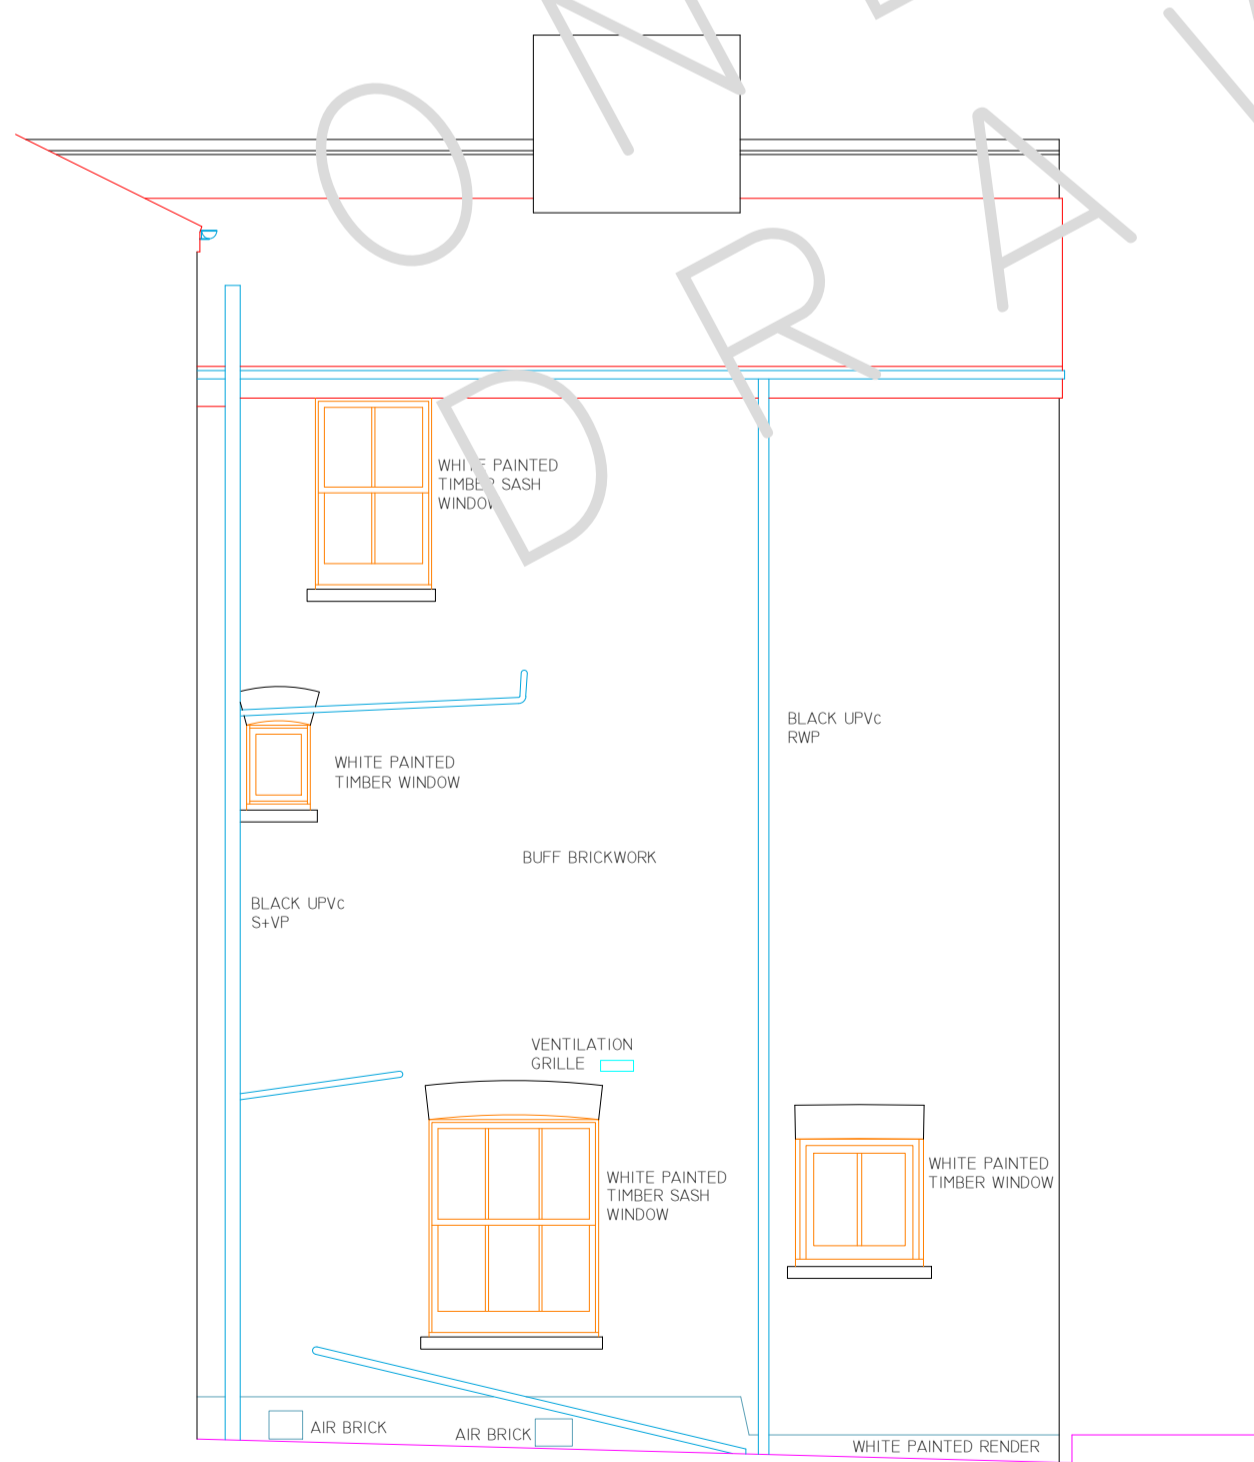

SOUTH ELEVATION
1:50 SCALE

95M LINE



SECTION A--A
1:50 SCALE

REV	DATE	AMENDMENTS

Mobile CAD Surveying office & on site

PROJECT: MEASURED BUILDING SURVEY
ADDRESS: 87 CROFTON ROAD,

DWG NO.: 03
DWG TITLE: ELEVATIONS & SECTION A--A
DWG DATE: 2018
DWG SIZE: SCALE AS SHOWN @ A1
DRAWN: LJ | CHECKED: MW | ISSUE: 1