



GROUND FLOOR  
1:50 SCALE @ A1

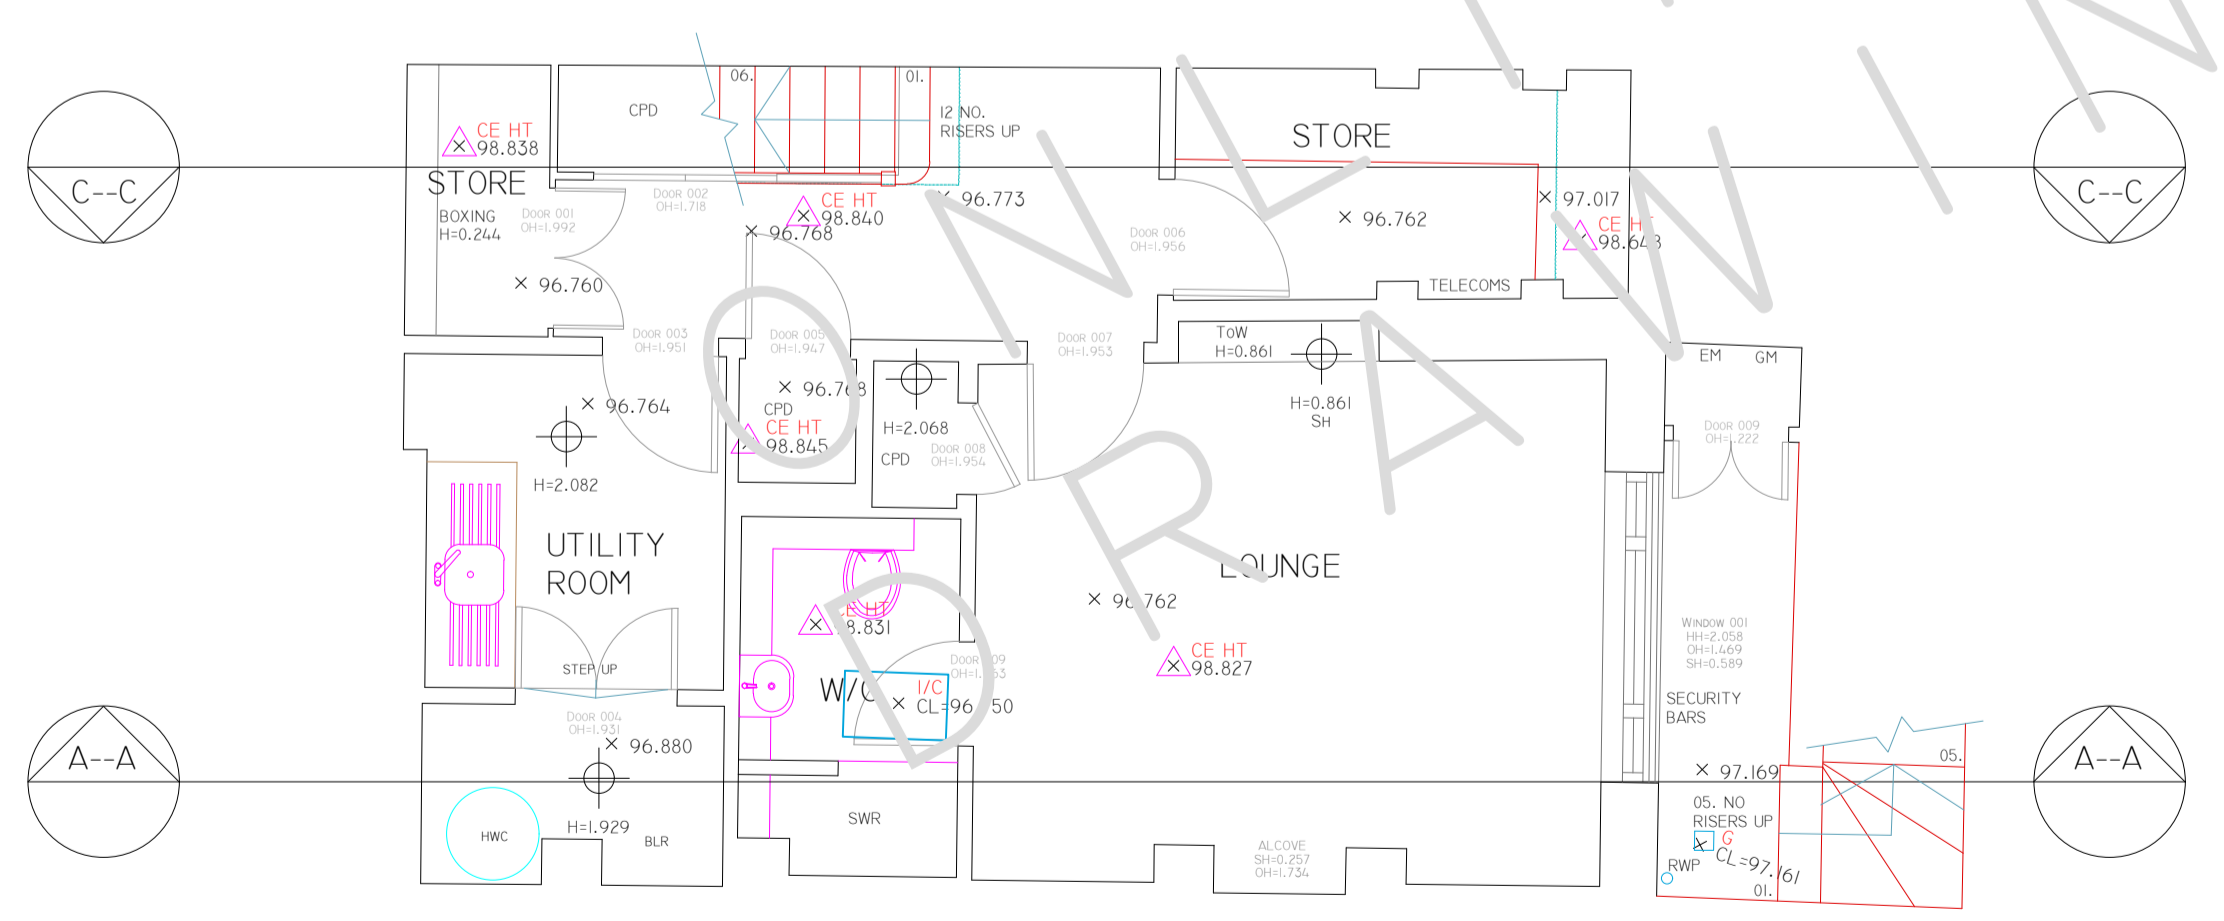

LOWER GROUND FLOOR  
1:50 SCALE @ A1

THIS DRAWING IS TO BE READ IN CONJUNCTION WITH ALL RELEVANT SPECIFICATIONS AND DRAWINGS ISSUED. FOR DISCREPANCIES OR OMISSIONS CONTACT MOBILE CAD SURVEYING SOLUTIONS LTD PRIOR TO WORK COMMENCING. THE CONTRACTOR IS TO CHECK AND VERIFY ALL BUILDING AND SITE DIMENSIONS AND LEVELS BEFORE WORK COMMENCES.  
© COPYRIGHT MOBILE CAD SURVEYING SOLUTIONS LTD 2018  
DO NOT SCALE THIS DRAWING - CHECK ALL DIMENSIONS ON SITE

NOTE:  
AREAS DRAWN INDICATIVELY NOTED AND INDICATED BY GREY DASHED LINE AS LINE BELOW

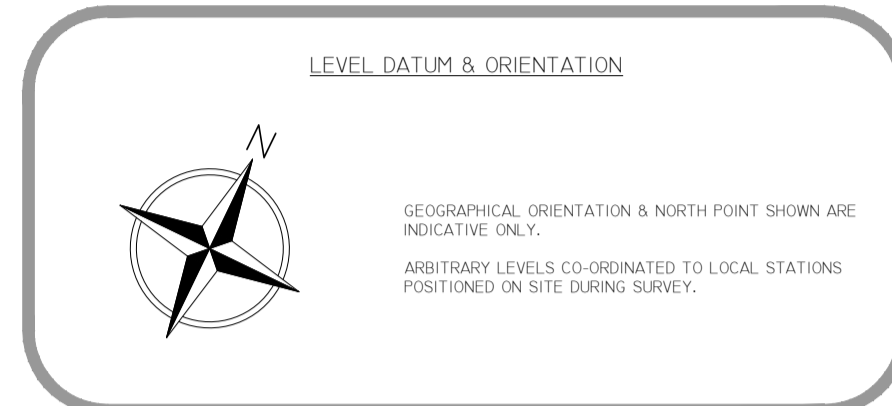

ABBREVIATIONS & LEGEND:

LEVELS & HEIGHTS	SERVICES
CL - COVER LEVEL	BT - BRITISH TELECOMS
IL - INVERT LEVEL	CATV - CABLE TELEVISION
L - LEVEL	ER - EARTHING ROD
HT - HEIGHT	ES - ELECTRICAL SUPPLY
STN - SURVEY STATION	FH - FIRE HYDRANT
BM - BENCH MARK	GS - GAS SUPPLY
CE - CEILING	PO - POST OFFICE TELEPHONE
V - VALVES	SV - STOP VALVE
RA - RAFTERS	TSU - TRAFFIC LIGHT SIGNAL
E - EAVES	
FR - FLAT ROOF	
P - PARAPET	
F - FENCE	
US - UNDERSIDE OF ROOF	
R - RIDGE	
SL - SLAB	
SF - SOFFIT	
T - TREE	
THR - THRESHOLD	
To - TOP OF	
W - WALL	
HH - HEAD HEIGHT	
OH - OPENING HEIGHT	
SH - SILL HEIGHT	
	DRAINAGE
	DC - DRAINAGE CHANNEL
	G - GULLY
	I - INSPECTION CHAMBER
	M - MANHOLE
	RE - RIDDING EYE
	RWP - RAIN WATER PIPE
	UTL - UNABLE TO LIFT
	S-WP - SOIL/WASTE PIPE
	ST - STOP TAP
	WM - WATER METER
	TYPICAL DRAWING SYMBOLS
	SPOT LEVEL x 96.256
	SPOT HEIGHT x 99.034
	SURVEY STATION
	MANHOLE / INSPECTION CHAMBER
	SURVEY HEIGHT
	WINDOW TAG
	DOOR TAG
	RADIATOR TAG
	TOPOGRAPHICAL SYMBOLS
	OVERHEAD ELECTRICAL
	OVERHEAD TELEPHONE
	FENCE LINE
	VEGETATION OUTLINE
	SINGLE GATE
	DOUBLE GATE
	TREE
	CONTOURS

REV	DATE	AMENDMENTS

Mobile CAD Surveying office & on site

PROJECT: MEASURED BUILDING SURVEY  
ADDRESS: 66 CHIPSTEAD STREET


DWG NO.: 01  
DWG TITLE: LOWER & GROUND FLOOR PLAN  
DWG DATE: 2018  
DWG SIZE: SCALE AS SHOWN @ A1  
DRAWN: JW | CHECKED: MW | ISSUE: 1

THIS DRAWING IS TO BE READ IN CONJUNCTION WITH ALL RELEVANT SPECIFICATIONS AND DRAWINGS ISSUED. FOR DISCREPANCIES OR OMISSIONS CONTACT MOBILE CAD SURVEYING SOLUTIONS LTD PRIOR TO WORK COMMENCING. THE CONTRACTOR IS TO CHECK AND VERIFY ALL BUILDING AND SITE DIMENSIONS AND LEVELS BEFORE WORK COMMENCES.

© COPYRIGHT MOBILE CAD SURVEYING SOLUTIONS LTD 2018



DO NOT SCALE THIS DRAWING - CHECK ALL DIMENSIONS ON SITE

NOTE:  
AREAS DRAWN INDICATIVELY NOTED AND INDICATED BY GREY DASHED LINE AS LINE BELOW

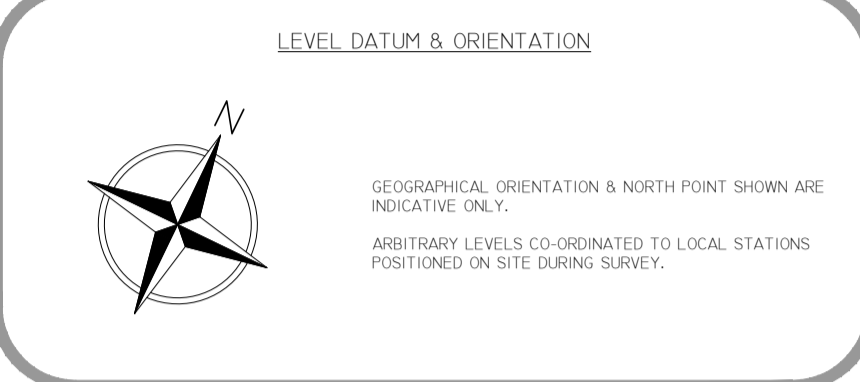

ABBREVIATIONS & LEGEND:

LEVELS & HEIGHTS	SERVICES
CL - COVER LEVEL	BT - BRITISH TELECOMS
IL - INVERT LEVEL	CATV - CABLE TELEVISION
L - LEVEL	ER - EARTHING ROD
HT - HEIGHT	ES - ELECTRICAL SUPPLY
STN - SURVEY STATION	EH - FIRE HYDRANT
BSH - BENCH	GS - GAS SUPPLY
CE - CEILING	PO - POST OFFICE TELEPHONE
J - JOISTS	SV - STOP VALVE
RA - RAFTERS	TSU - TRAFFIC LIGHT SIGNAL
E - EAVES	
FR - FLAT ROOF	
P - PARAPET	
F - FENCE	
US - UNDERSIDE OF	
R - ROOF	
SL - SLAB	
SF - SOFFIT	
T - TREE	
THR - THRESHOLD	
To - TOP OF	
W - WALL	
HH - HEAD HEIGHT	
OH - OPENING HEIGHT	
SH - SILL HEIGHT	
CEILING NOTES	
AC - AIR CONDITIONING UNIT	
AU - AIR HANDLING UNIT	
AP - AIR FILTER ALARM PANEL	
B - BULLARD	
BA - BARRIER	
BE - BENCH	
BS - BUS STOP	
BOL - BOILER	
BOX - BOXING OUT	
CAH - CEILING ACCESS HATCH	
CH - CHIMNEY	
CLP - CLIPBOARD	
DB - DOG WASTE BIN	
DW - DWELL WALL	
DK - DROP KUBES	
EDB - ELECTRICAL DISTRIBUTION BOARD	
EG - EXTRACT FURLE	
M - ELECTRIC METER	
FB - FUSE BOX	
FI - FIREPLACE	
FL - FLE	
FAP - FIRE ALARM PANEL	
GU - GUSSING	
GM - GAS METER	
HWC - HOT WATER CYLINDER	
LAM - LOFT ACCESS HATCH	
LBP - LITTER BIN	
LP - LAMP POST	
PC - PAVING CROSSING	
PS - PAVING SLABS	
PL - PAVEMENT LIGHT	
PLT - PLANTING	
PB - POST BOX	
RS - ROAD SIGN	
SP - SPEED BUMP	
SG - SIGNAGE	
SN - STREET NAME SIGN	
SWR - SHOWER	
SHV - SHELVEING	
TB - TELEPHONE BOX	
TL - TRAFFIC LIGHT	
TM - TICKET MACHINE	
TP - TELEGRAPH POLE	
W - WATER	
WD - WARDROBE	
WH - WATER HEATER	
ZC - ZEBRA CROSSING	

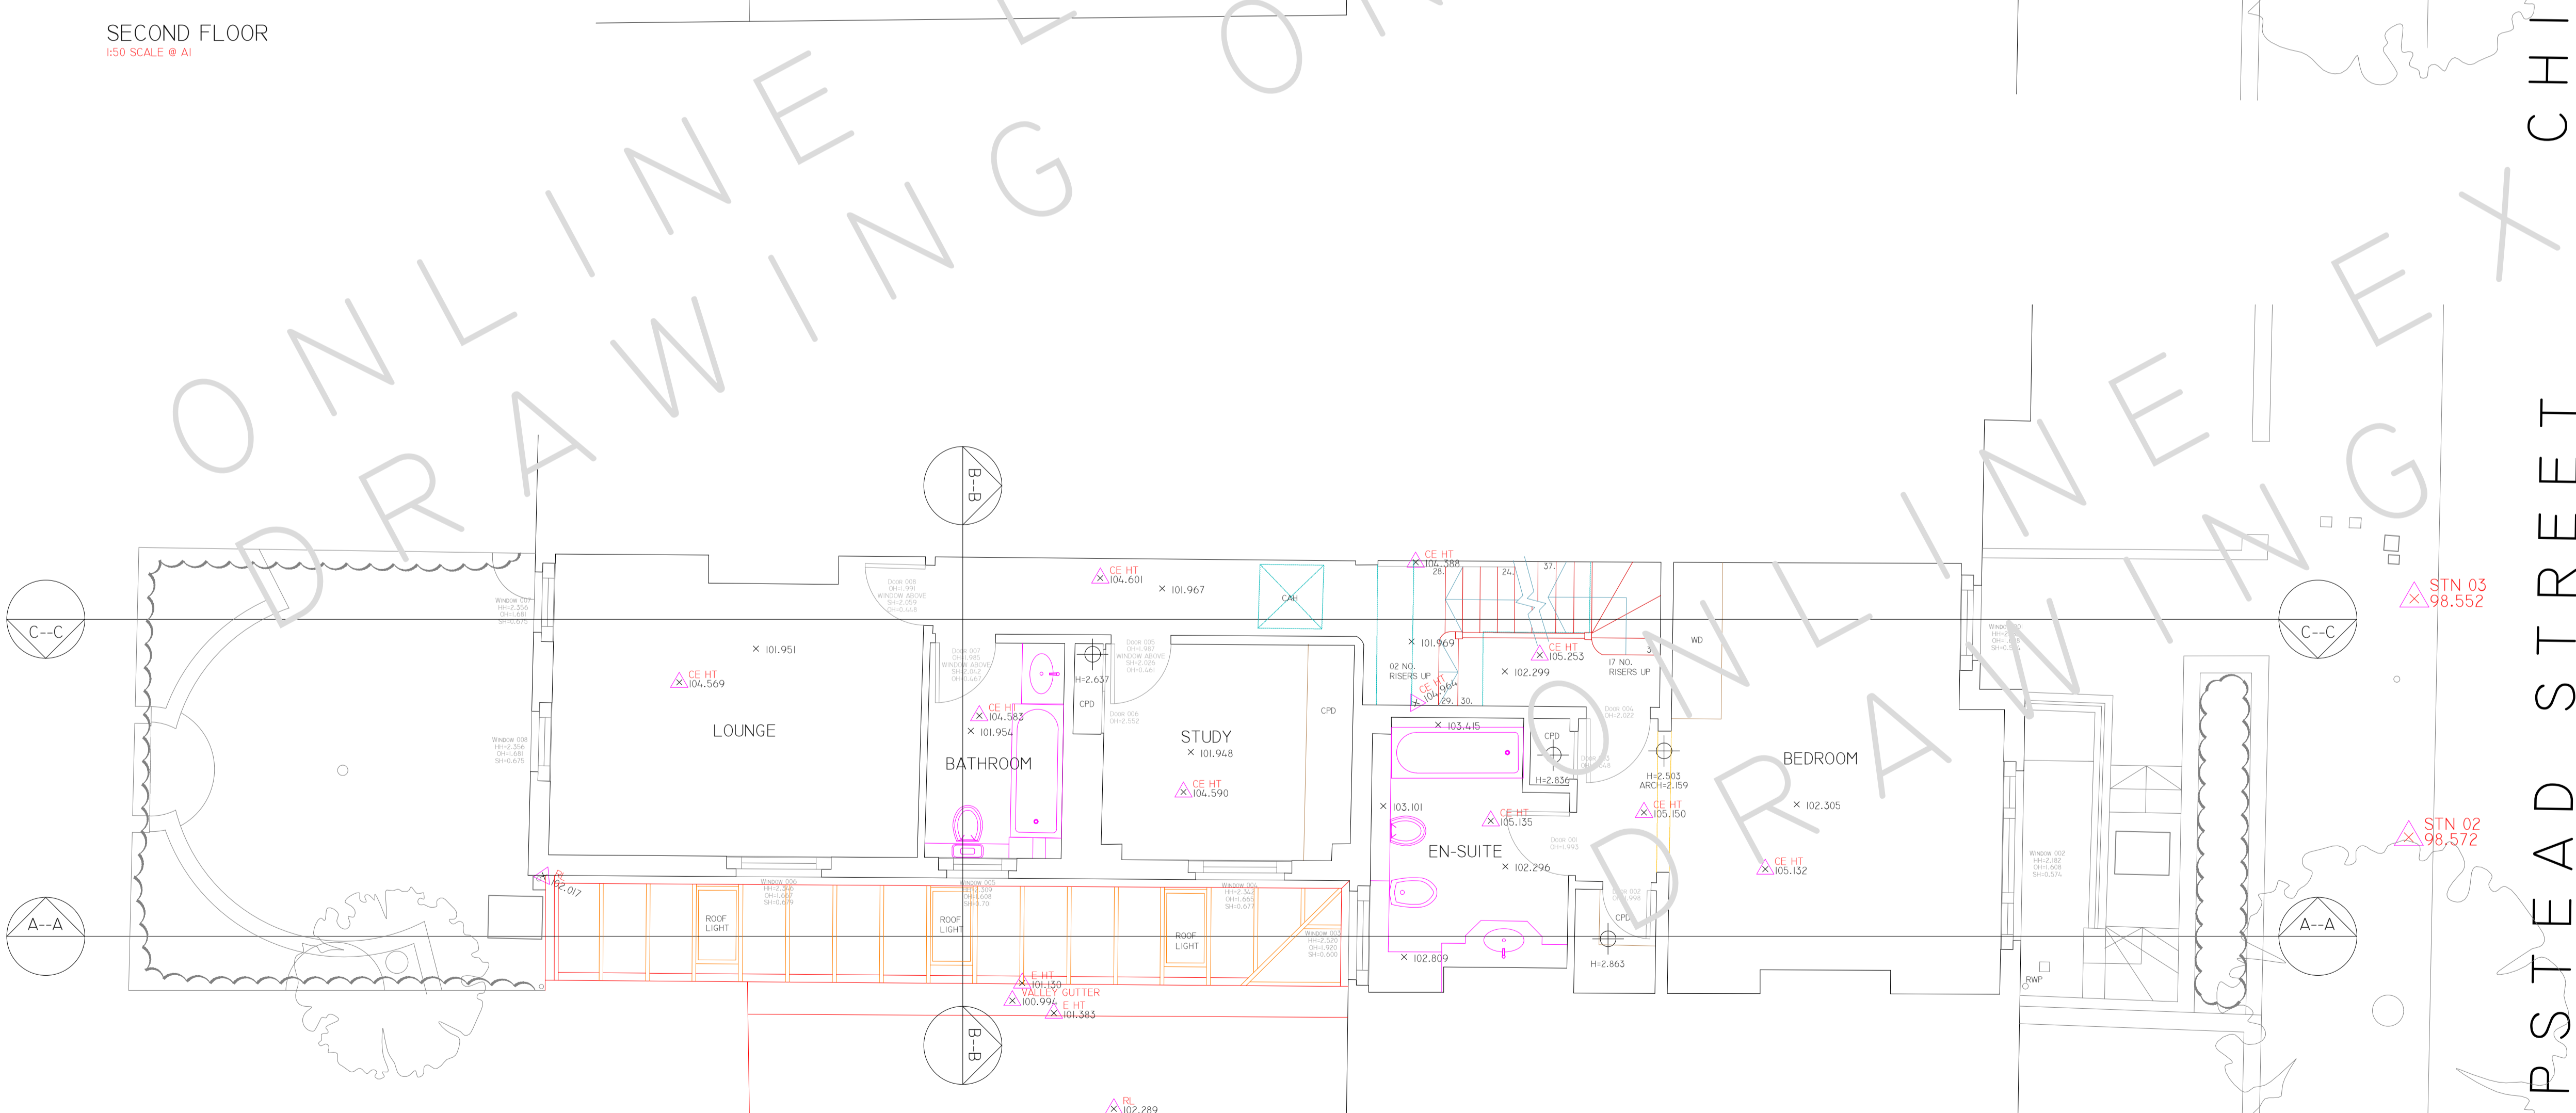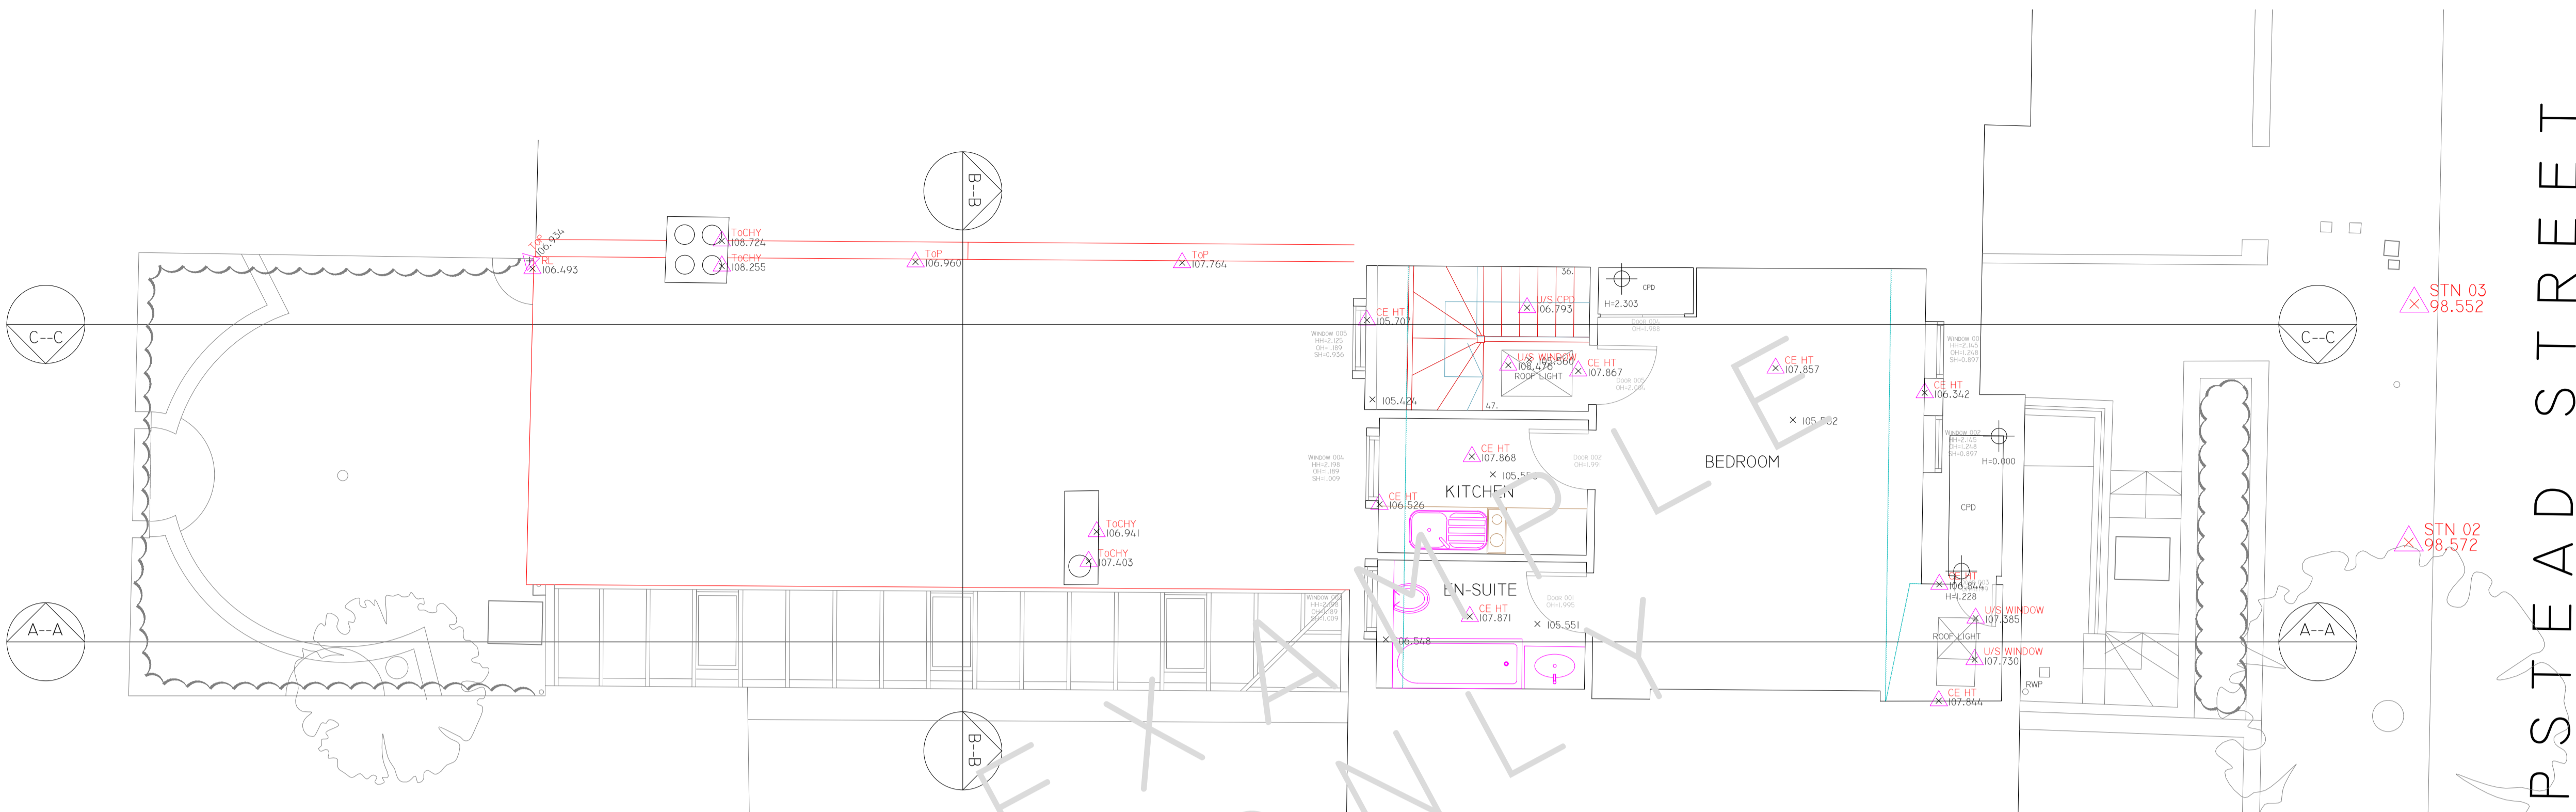

REV	DATE	AMENDMENTS

PROJECT: MEASURED BUILDING SURVEY  
ADDRESS: 6A CHIPSTEAD STREET,  
DWG NO.: 02  
DWG TITLE: FIRST & SECOND FLOOR PLAN  
DWG DATE: 2018  
DWG SIZE: SCALE AS SHOWN @ A1  
DRAWN: JW | CHECKED: MW | ISSUE:  

CHIPSTEAD STREET


ONLINE DRAWING ONLY

THIS DRAWING IS TO BE READ IN CONJUNCTION WITH ALL RELEVANT SPECIFICATIONS AND DRAWINGS ISSUED. FOR DISCREPANCIES OR OMISSIONS CONTACT MOBILE CAD SURVEYING SOLUTIONS LTD PRIOR TO WORK COMMENCING. THE CONTRACTOR IS TO CHECK AND VERIFY ALL BUILDING AND SITE DIMENSIONS AND LEVELS BEFORE WORK COMMENCES.

© COPYRIGHT MOBILE CAD SURVEYING SOLUTIONS LTD 2018



DO NOT SCALE THIS DRAWING - CHECK ALL DIMENSIONS ON SITE

NOTE:  
AREAS DRAWN INDICATIVELY NOTED AND INDICATED BY GREY DASHED LINE AS LINE BELOW

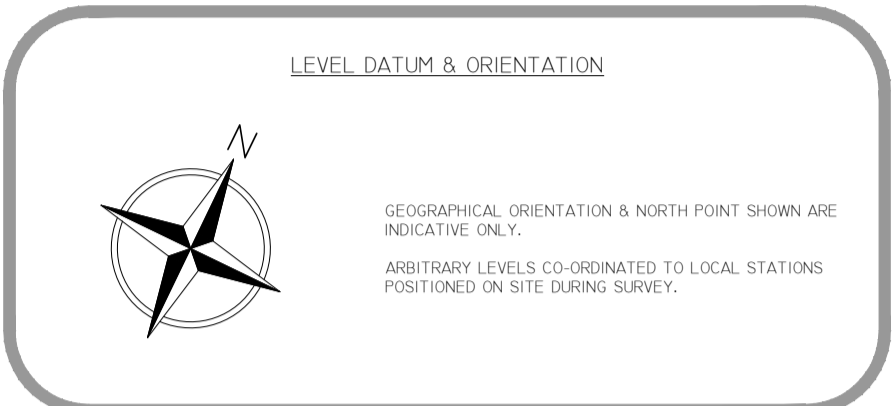

ABBREVIATIONS & LEGEND:

LEVELS & HEIGHTS	SERVICES
CL - COVER LEVEL	BT - BRITISH TELECOMS
IL - INVERT LEVEL	CATV - CABLE TELEVISION
EL - LEVEL	ER - EARTHING ROD
HT - HEIGHT	ES - ELECTRICAL SUPPLY
STN - SURVEY STATION	EH - FIRE HYDRANT
BH - BENCH	GS - GAS SUPPLY
CE - CEILING	PO - POST OFFICE TELEPHONE
V - VALVES	SV - STOP VALVE
RA - RAFTERS	TSU - TRAFFIC LIGHT SIGNAL
E - EAVES	
FR - FLAT ROOF	
P - PARAPET	
F - FENCE	
US - UNDERSIDE OF	
R - ROOF	
SL - SLAB	
SF - SOFFIT	
T - TREE	
THR - THRESHOLD	
To - TOP OF	
W - WALL	
HH - HEAD HEIGHT	
OH - OPENING HEIGHT	
SH - SILL HEIGHT	
GENERAL NOTES	
AB - ADVERTISING BOARD	
AC - AIR CONDITIONING UNIT	
AU - AIR HANDLING UNIT	
AP - ALARMS PANEL	
B - BULL LARD	
BA - BARRIER	
BE - BENCH	
BS - BUS STOP	
BU - BUIER	
BXD - BOXING OUT	
CAH - CEILING ACCESS HATCH	
CH - CHIMNEY	
CHD - CHIMNEY	
DB - DOG WASTE BIN	
DW - DWELLING WALL	
DK - DROP KUBES	
EDB - ELECTRICAL DISTRIBUTION BOARD	
EG - EXTRACT TUBULE	
M - ELECTRIC METER	
FB - FUSE BOX	
FP - FIRE PLACE	
FU - FUSE	
FAP - FIRE ALARM PANEL	
GU - GRASS	
GM - GAS METER	
HWC - HOT WATER CYLINDER	
LAM - LAMP POST	
LB - LITTER BIN	
LP - LAMP POST	
PC - PELICAN CROSSING	
PS - PAVING SLABS	
PL - PAVEMENT LIGHT	
PLT - PLANTING	
PB - POST BOX	
RS - RAILING	
RS - ROAD SIGN	
SP - SPEED BUMP	
SG - SIGNAGE	
SN - STREET NAME SIGN	
SWR - SHOWER	
SHV - SHELVING	
TB - TELEPHONE BOX	
TL - TRAFFIC LIGHT	
TM - TICKET MACHINE	
TP - TELEGRAPH POLE	
W - WATER	
WD - WARDROBE	
WH - WATER HEATER	
ZC - ZEBRA CROSSING	

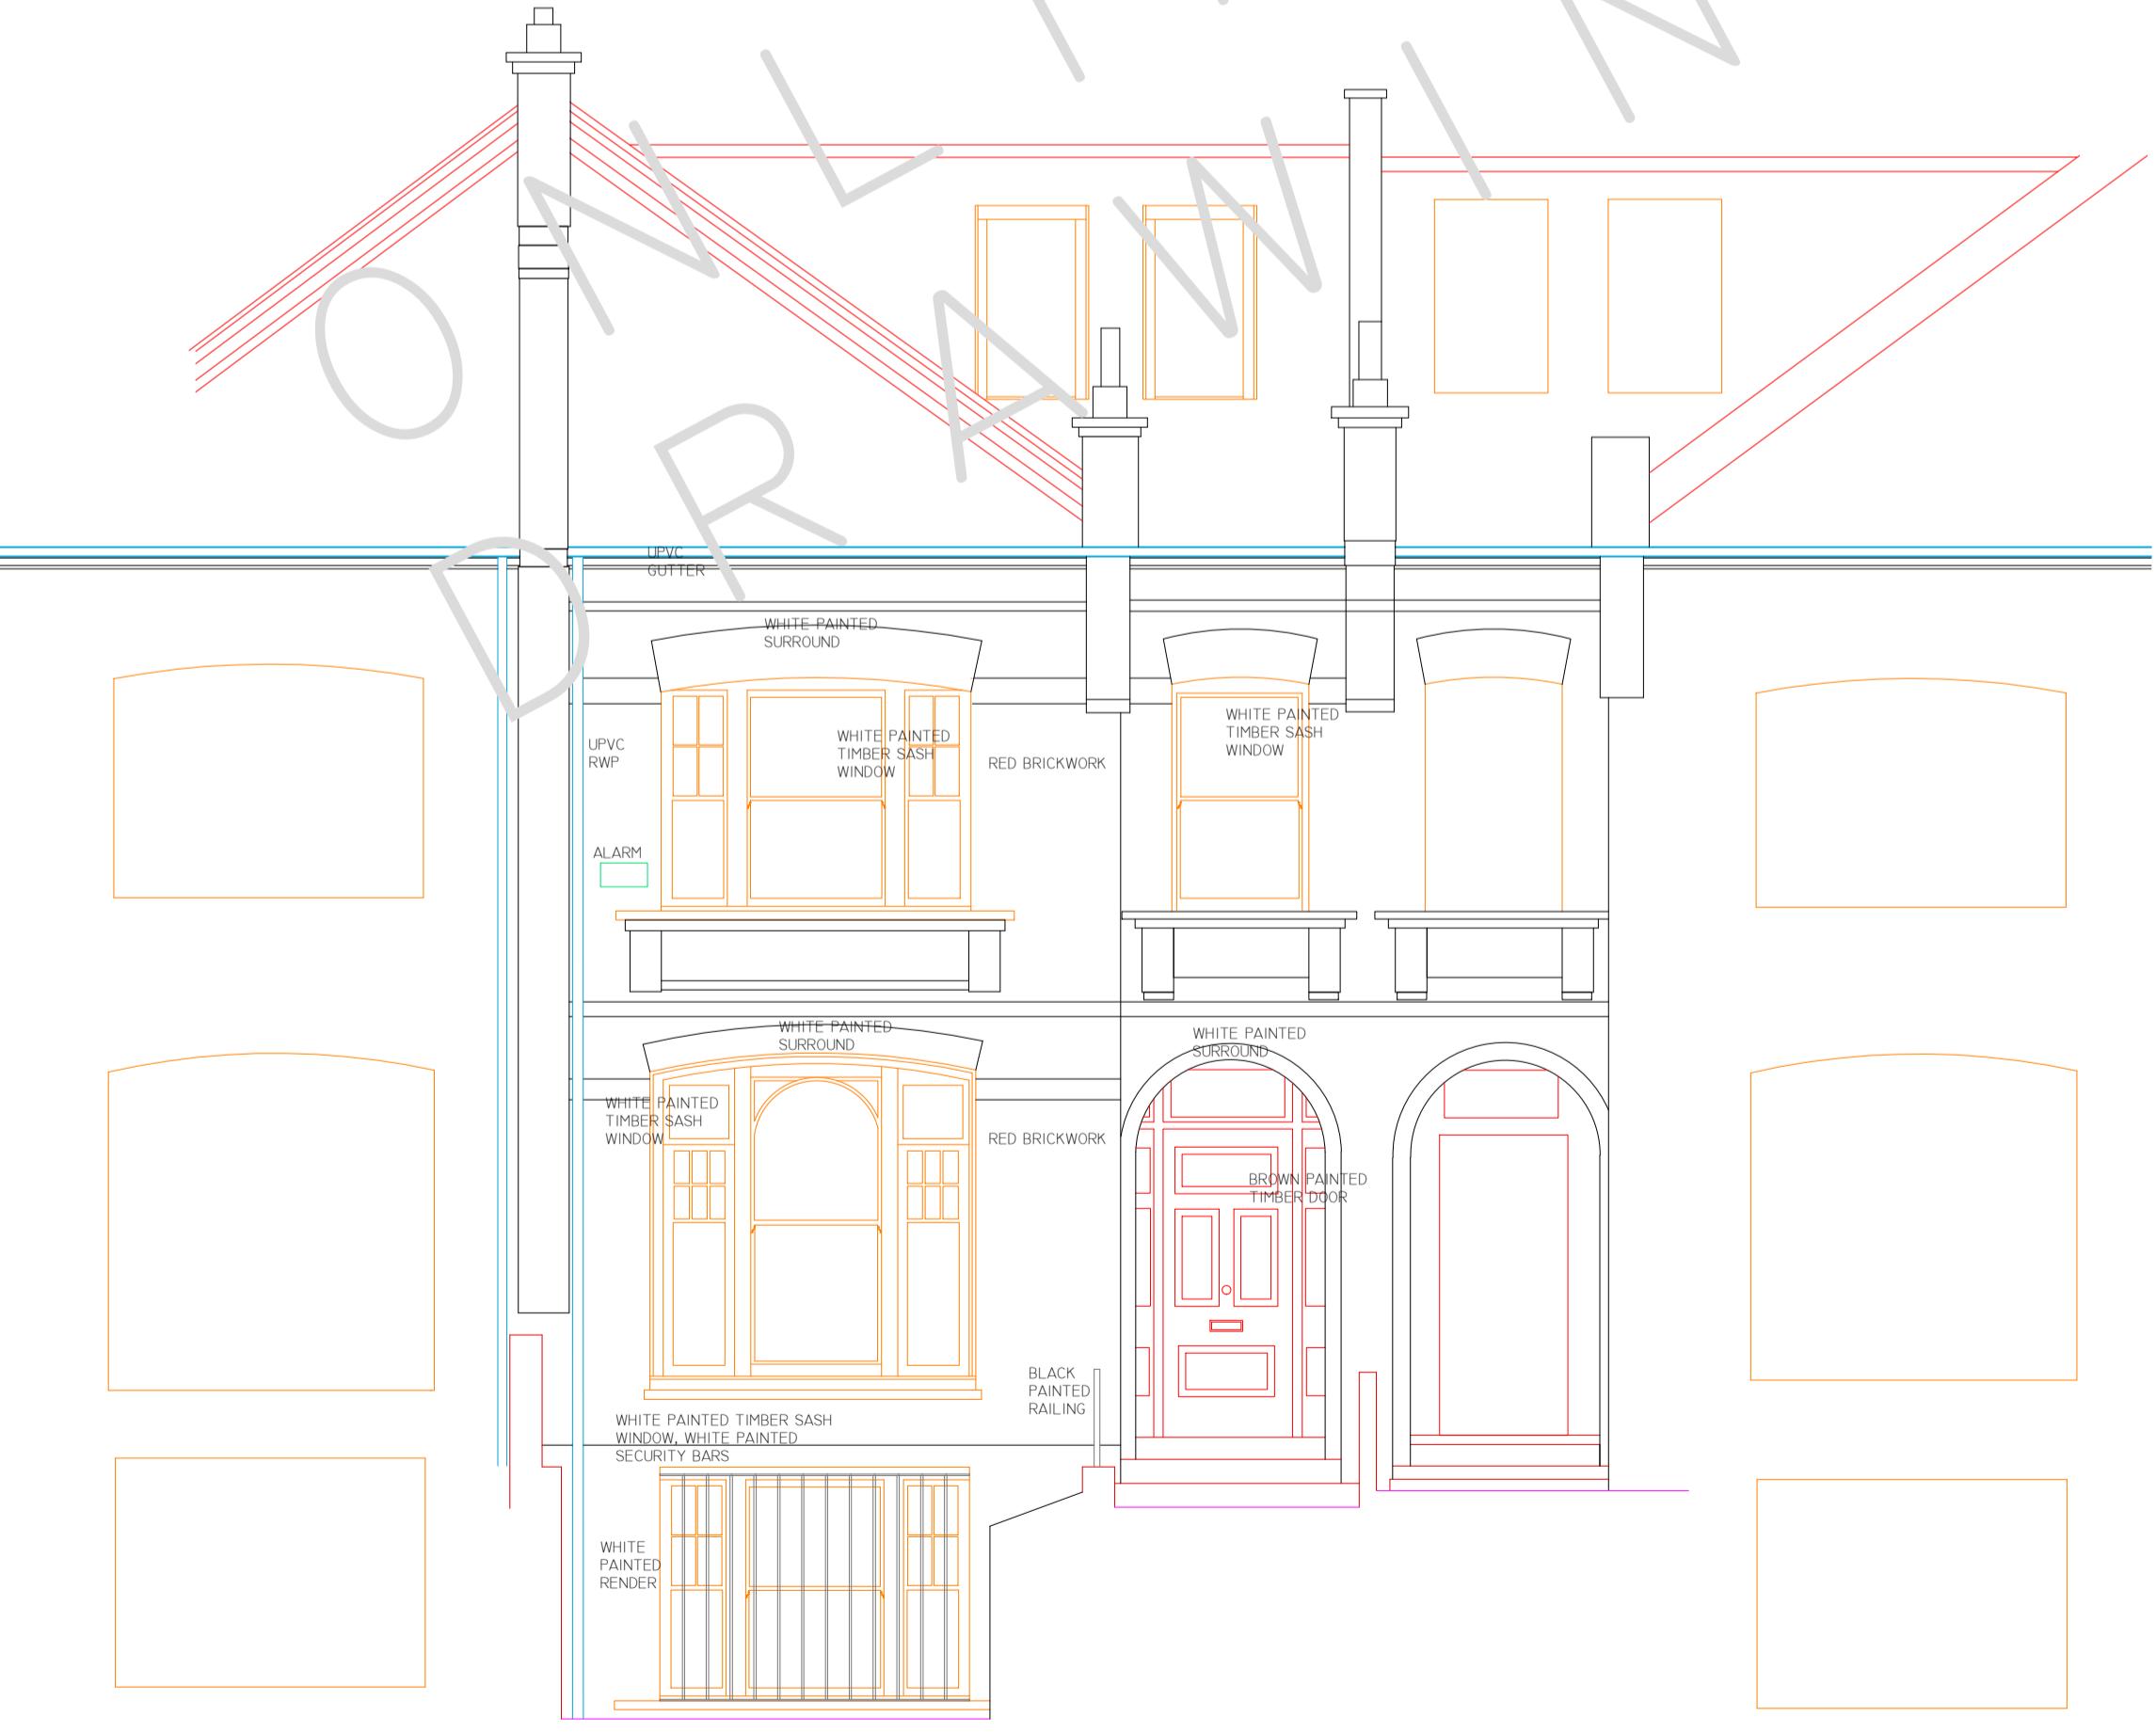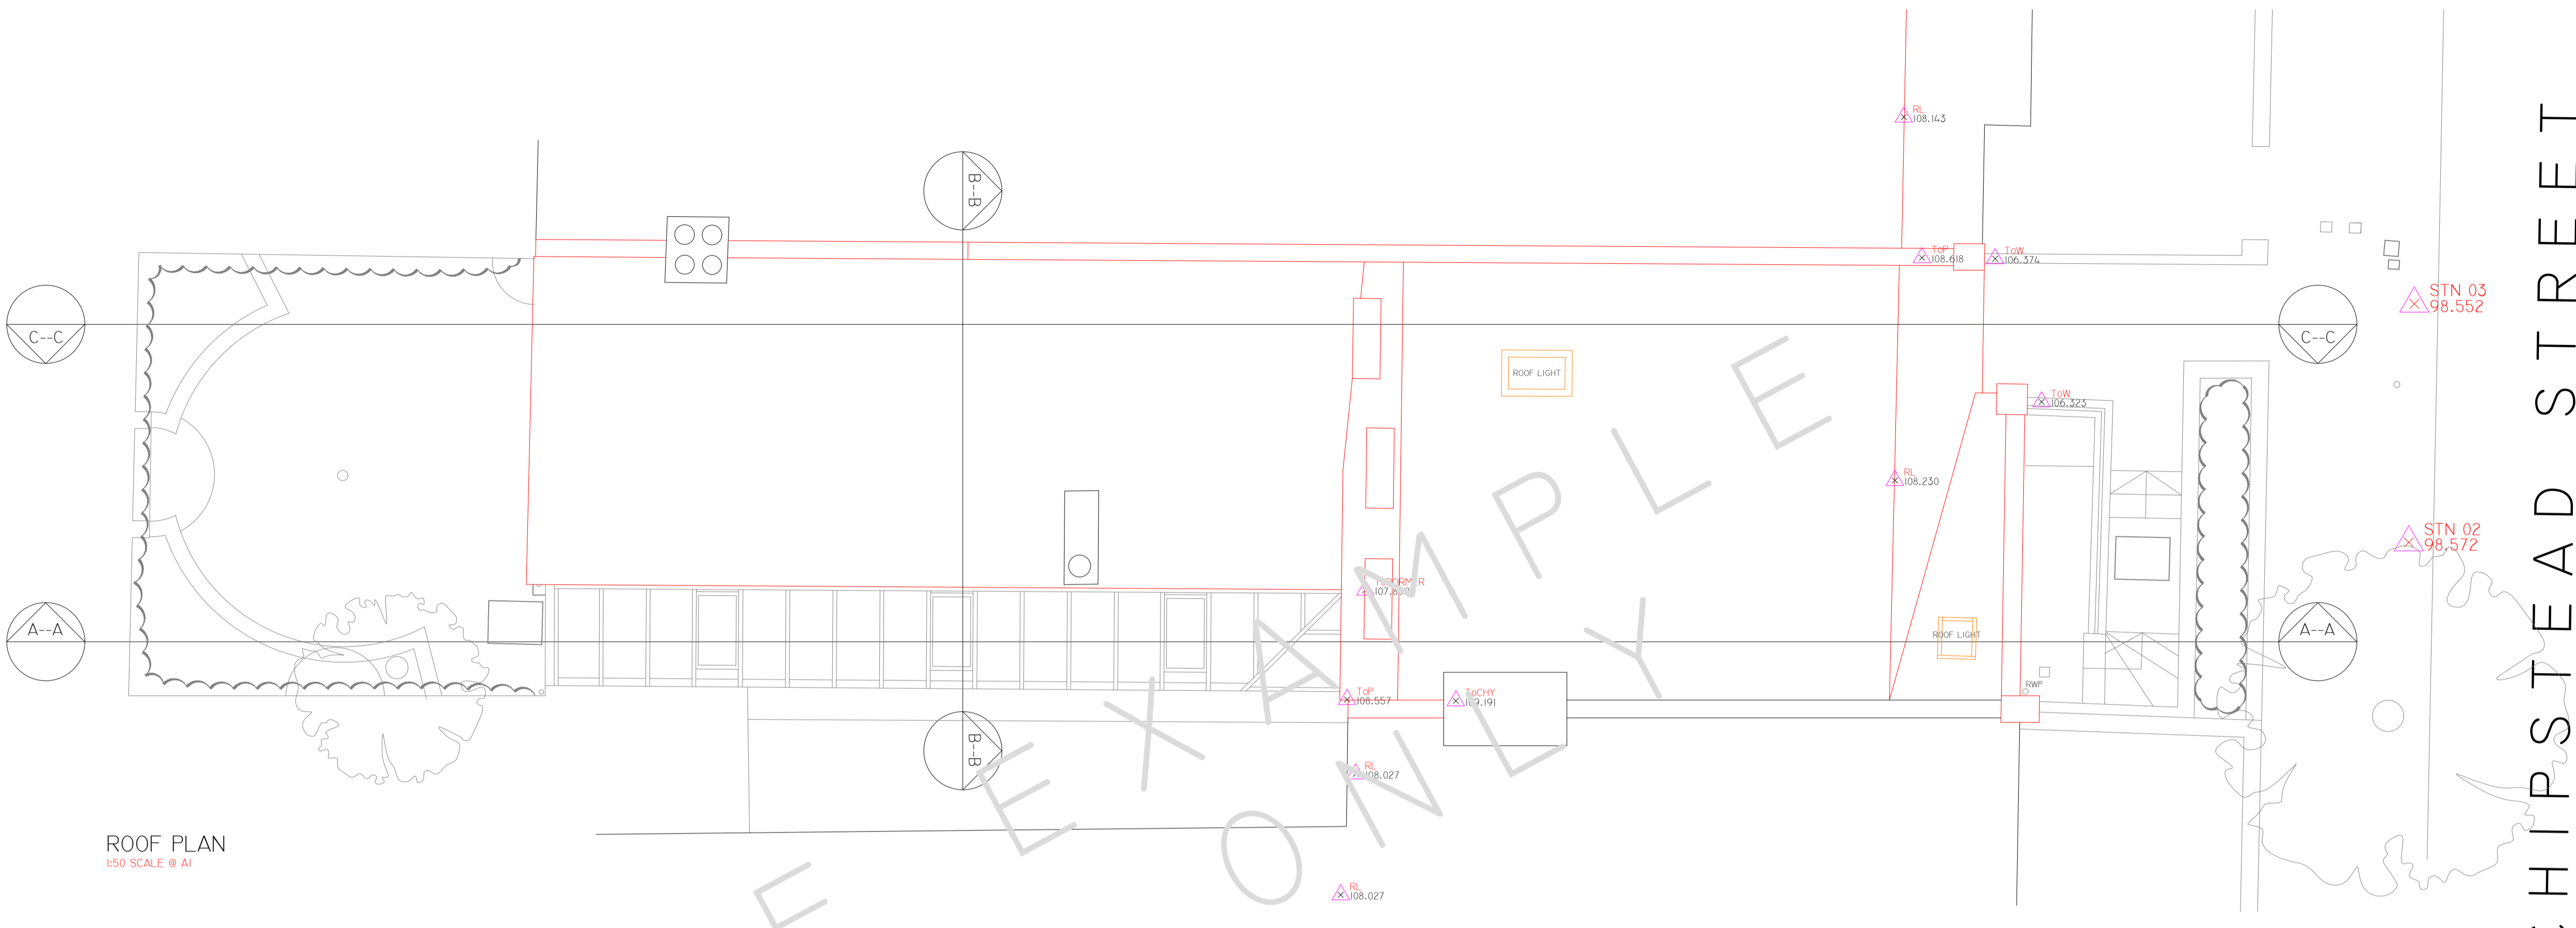

REV	DATE	AMENDMENTS

Mobile CAD Surveying office & on site

PROJECT: MEASURED BUILDING SURVEY  
ADDRESS: 64 CHIPSTEAD STREET.

DWG NO.: 03  
DWG TITLE: ROOF PLAN & ELEVATIONS  
DWG DATE: 2018  
DWG SIZE: SCALE AS SHOWN @ A1  
DRAWN: JW | CHECKED: MW | ISSUE: 1

96M LINE


96M LINE

THIS DRAWING IS TO BE READ IN CONJUNCTION WITH ALL RELEVANT SPECIFICATIONS AND DRAWINGS ISSUED. FOR DISCREPANCIES OR OMISSIONS CONTACT MOBILE CAD SURVEYING SOLUTIONS LTD PRIOR TO WORK COMMENCING. THE CONTRACTOR IS TO CHECK AND VERIFY ALL BUILDING AND SITE DIMENSIONS AND LEVELS BEFORE WORK COMMENCES.  
 © COPYRIGHT MOBILE CAD SURVEYING SOLUTIONS LTD 2018  
 DO NOT SCALE THIS DRAWING - CHECK ALL DIMENSIONS ON SITE

NOTE:  
 AREAS DRAWN INDICATIVELY NOTED AND INDICATED BY GREY DASHED LINE AS LINE BELOW  
 -----




SECTION A--A  
 1:50 SCALE @ A1  
 96M LINE

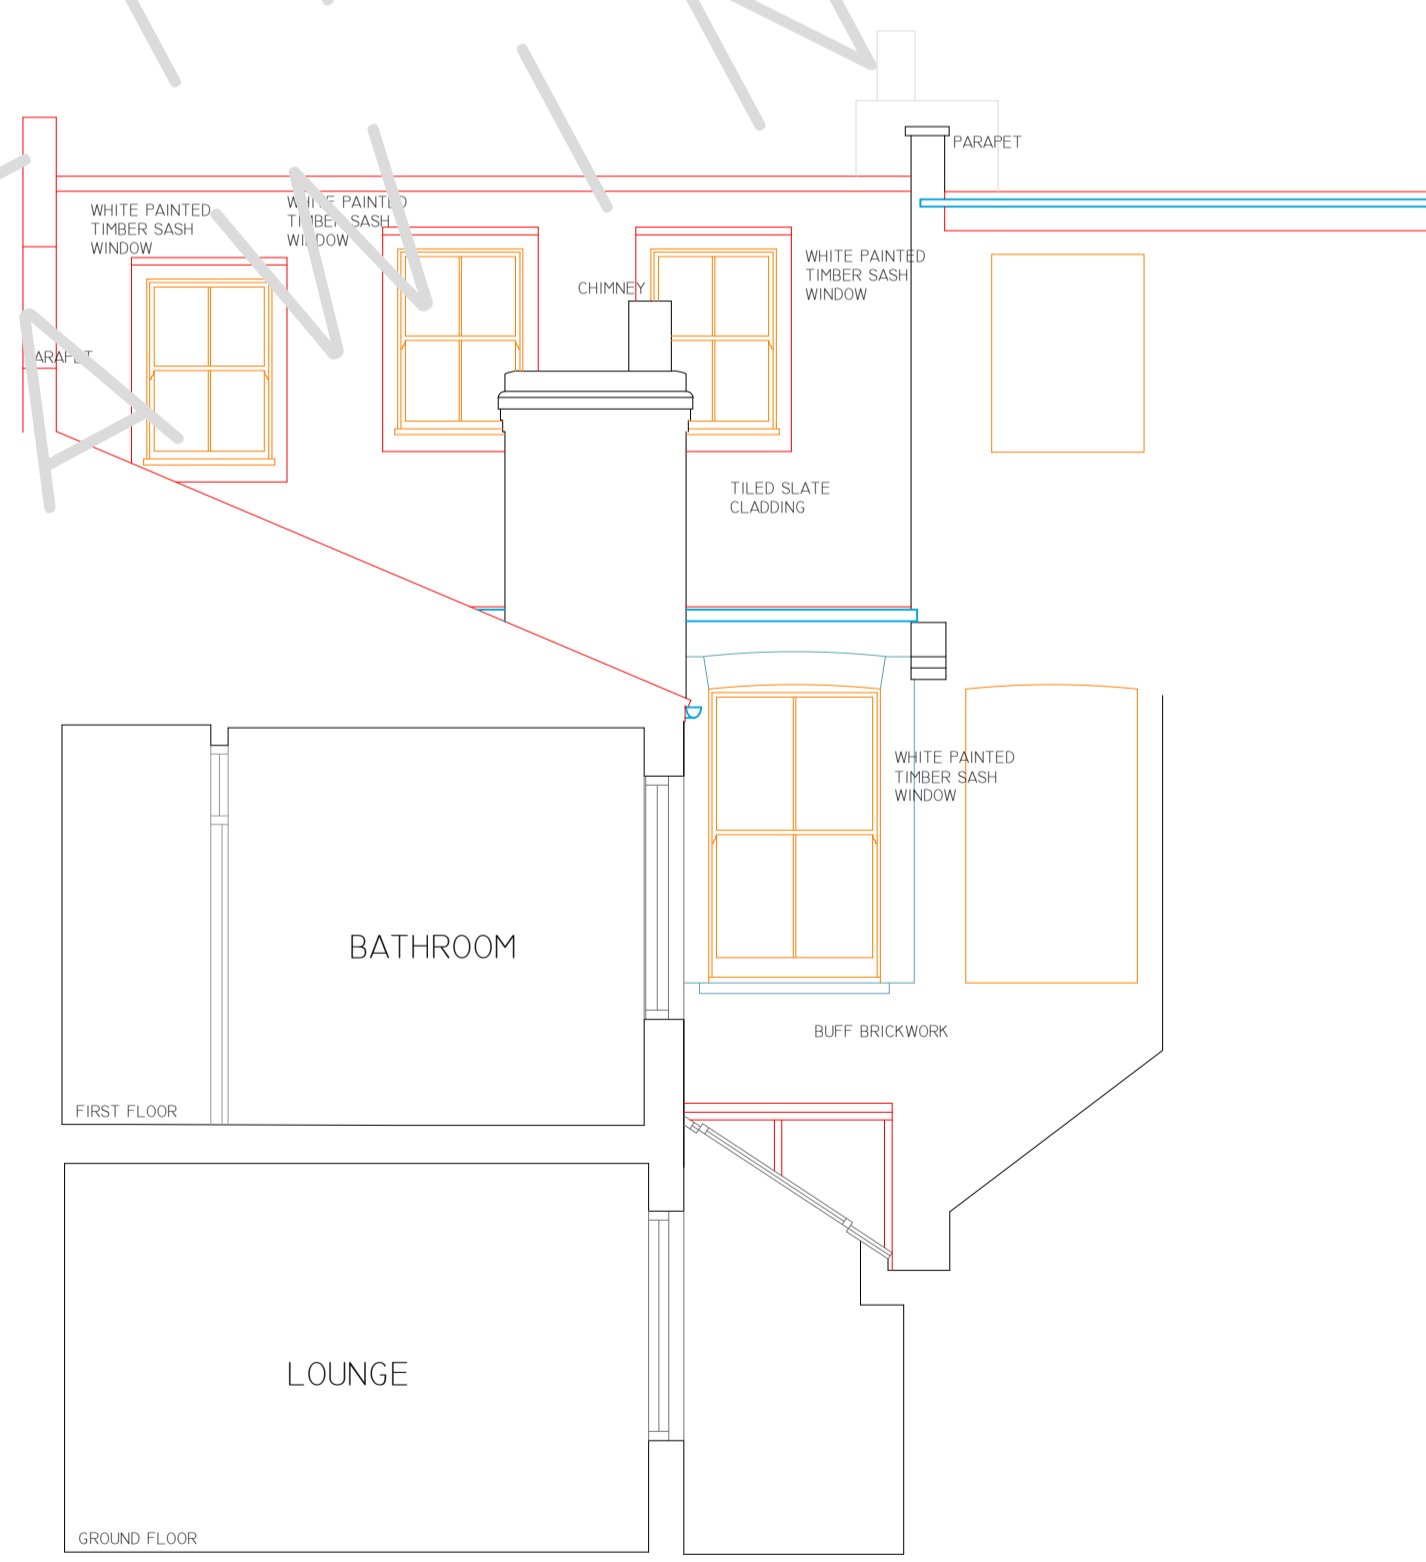

SECTION B--B  
 1:50 SCALE @ A1  
 96M LINE


ONLINE DRAWING EXAMPLE ONLY

REV	DATE	AMENDMENTS


 office & on site  
 PROJECT: MEASURED BUILDING SURVEY  
 ADDRESS: 64 CHIPSTEAD STREET,  
 DWG NO.: 04  
 DWG TITLE: SECTIONS A--A & B--B  
 DWG DATE: 2018  
 DWG SIZE: SCALE AS SHOWN @ A1  
 DRAWN: JW | CHECKED: MW | ISSUE: 1

THIS DRAWING IS TO BE READ IN CONJUNCTION WITH ALL RELEVANT SPECIFICATIONS AND DRAWINGS ISSUED. FOR DISCREPANCIES OR OMISSIONS CONTACT MOBILE CAD SURVEYING SOLUTIONS LTD PRIOR TO WORK COMMENCING. THE CONTRACTOR IS TO CHECK AND VERIFY ALL BUILDING AND SITE DIMENSIONS AND LEVELS BEFORE WORK COMMENCES.  
 © COPYRIGHT MOBILE CAD SURVEYING SOLUTIONS LTD 2018  
 DO NOT SCALE THIS DRAWING - CHECK ALL DIMENSIONS ON SITE


NOTE:  
 AREAS DRAWN INDICATIVELY NOTED AND INDICATED BY GREY DASHED LINE AS LINE BELOW

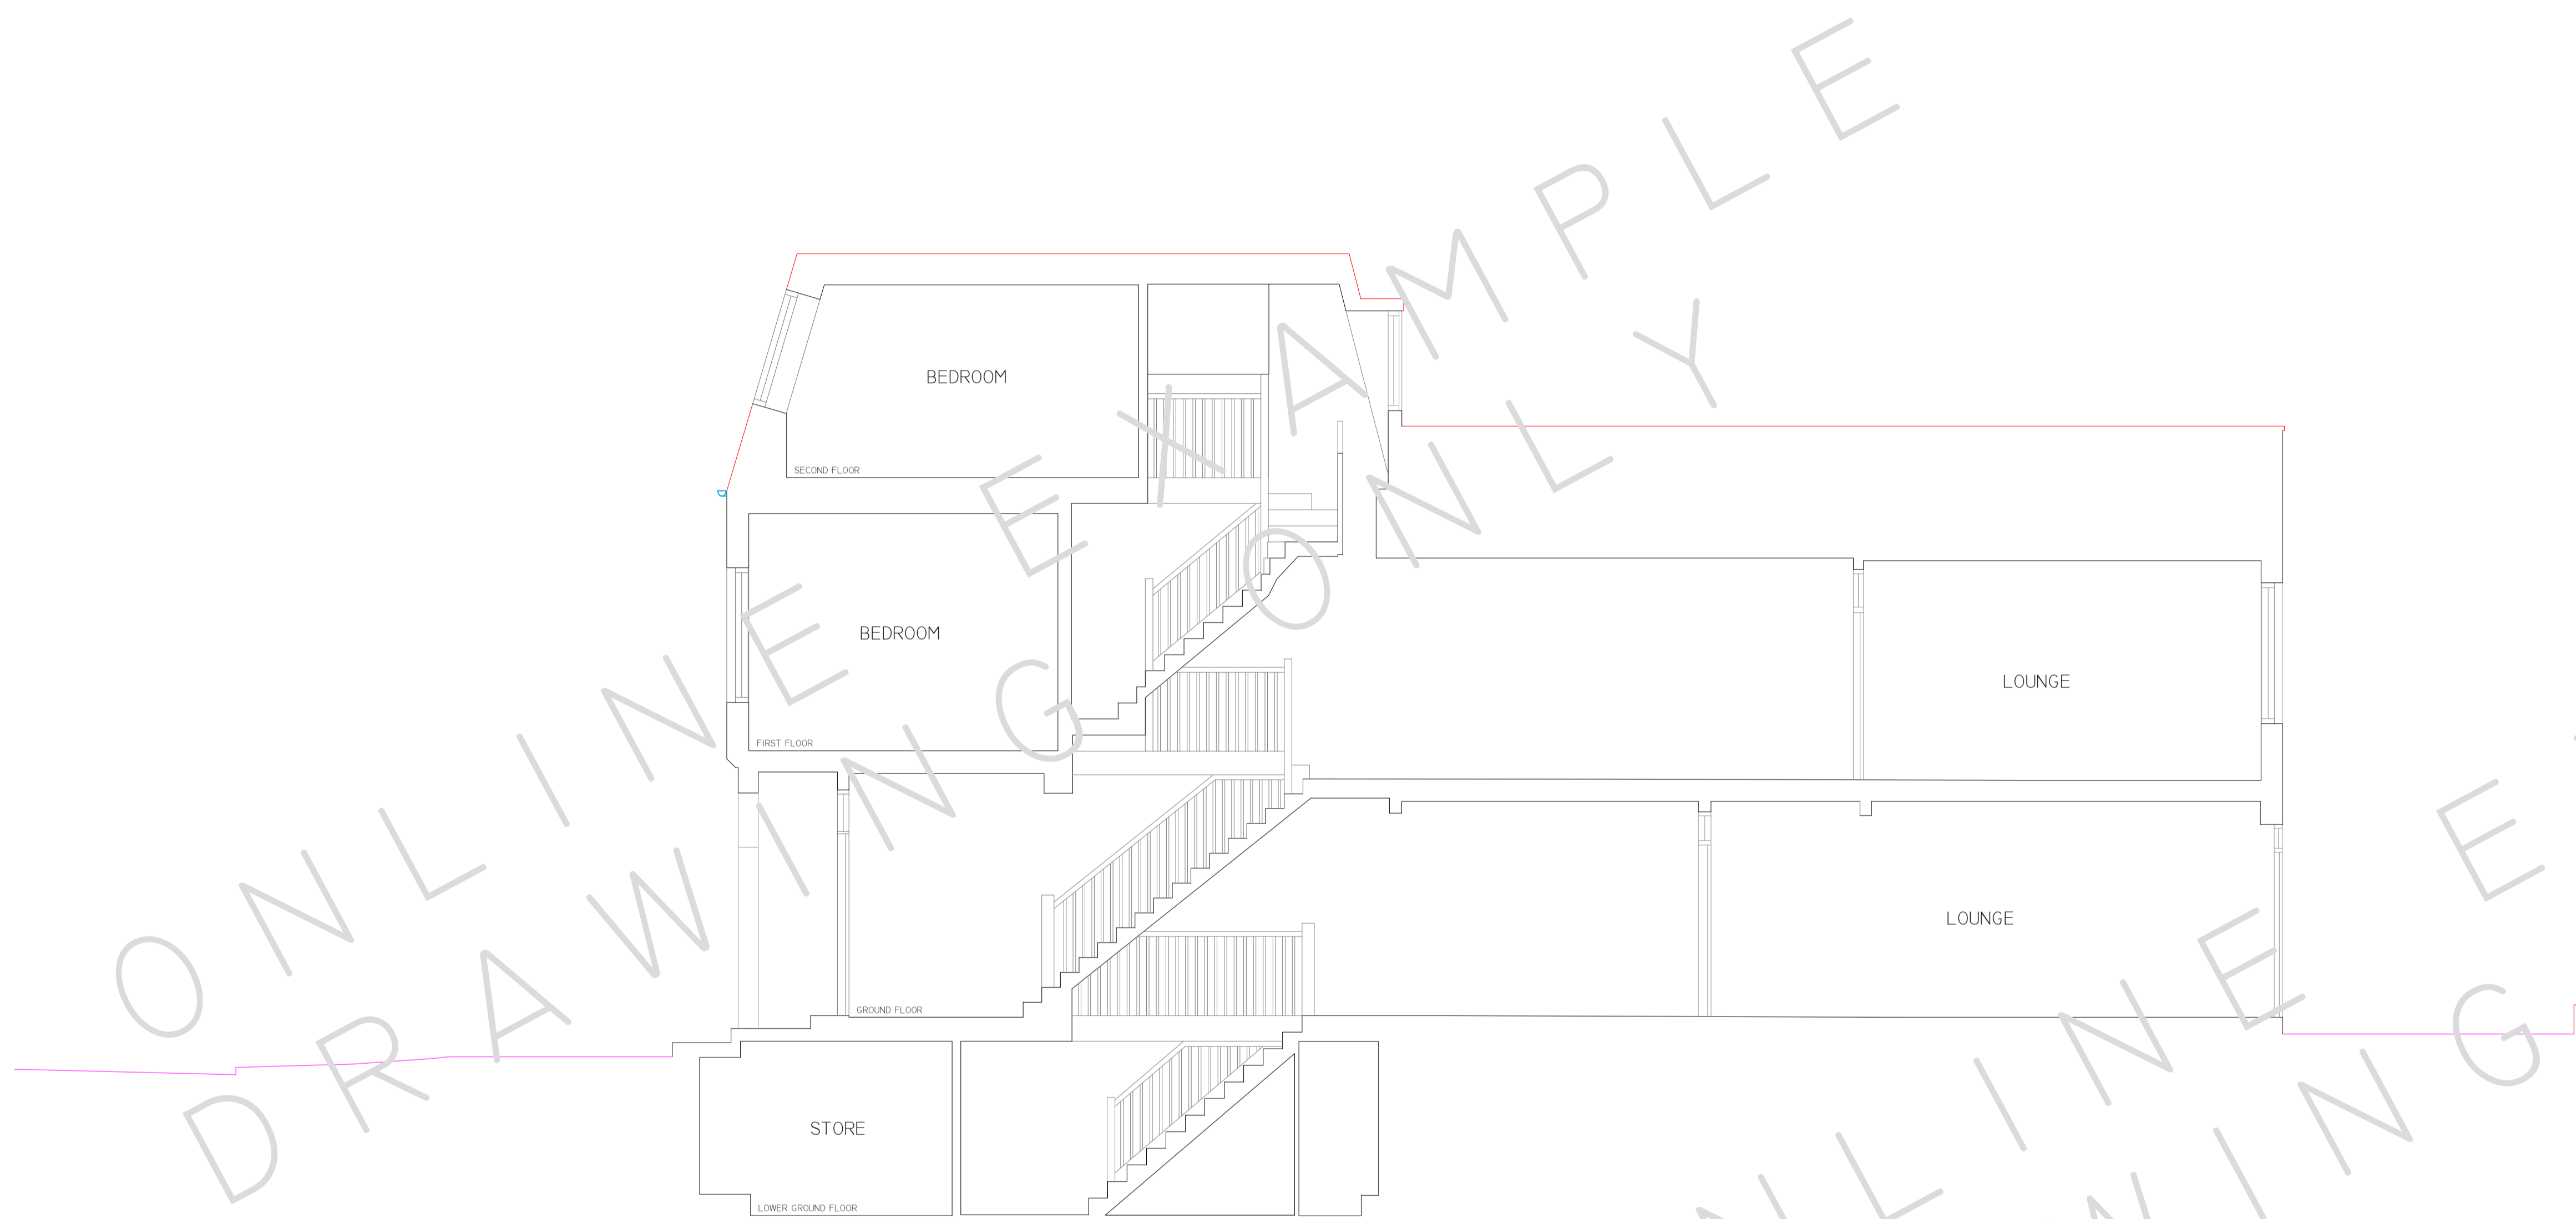

96M LINE

SECTION C--C  
 1:50 SCALE @ A1

REV	DATE	AMENDMENTS

 <p>office &amp; on site</p>	PROJECT: MEASURED BUILDING SURVEY
	ADDRESS: 64 CHIPSTEAD STREET,
	DWG NO.: 05
	DWG TITLE: SECTIONS C--C
	DWG DATE: 2018
DWG SIZE: SCALE AS SHOWN @ A1	
DRAWN: JW	CHECKED: MW